
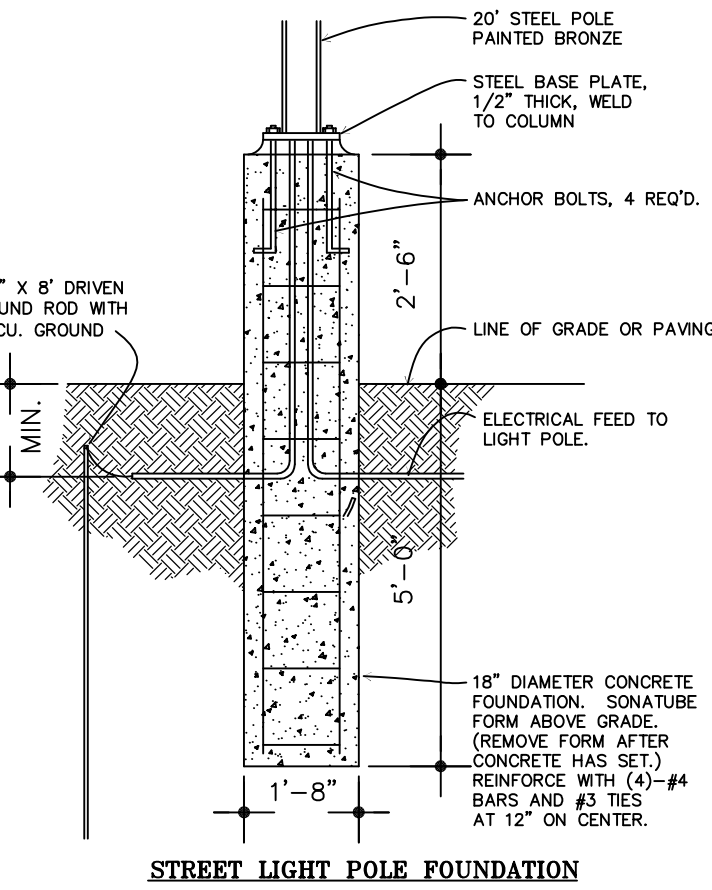


NO CONSTRUCTION VEHICLES ALLOWED THROUGH DEER RIDGE SUBDIVISION. ALL CONSTRUCTION VEHICLES TO USE ROUTE 9 ENTRANCE.

AS PART OF THIS APPROVAL THE DEVELOPER AGREES TO INSTALL A 'NO THRU TRAFFIC' SIGN AT THE ENTRANCE OF DEER RIDGE DRIVE AND ROUTE 125.

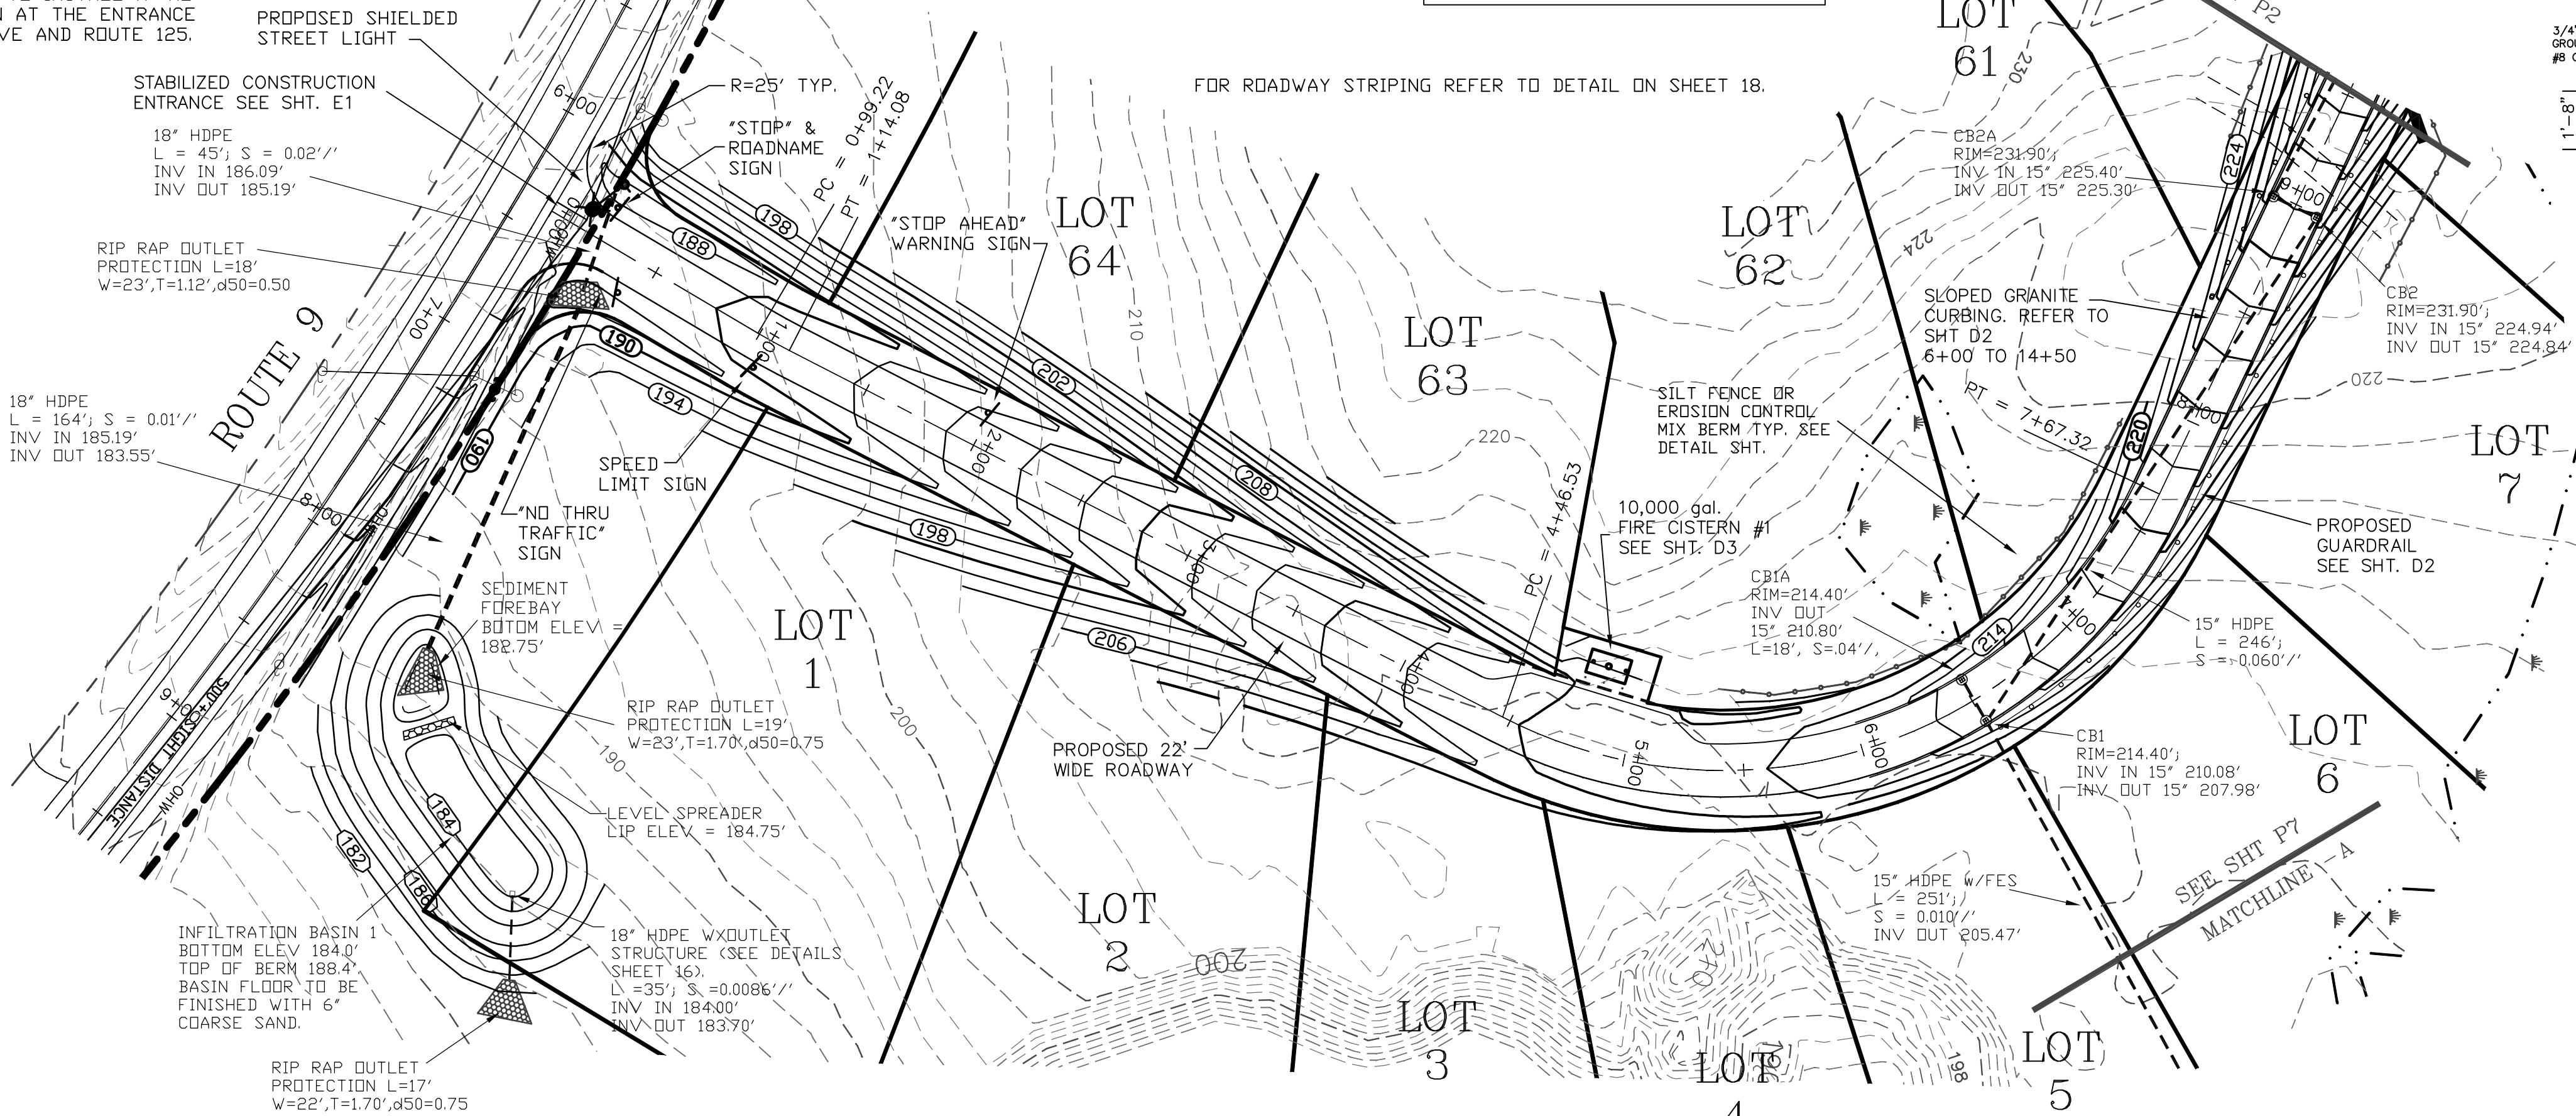



PREPARED FOR:

HARBOR STREET LTD.
PARTNERSHIP
7B EMERY LANE
STRATHAM, NH 03885

BEALS ASSOCIATES PLLC

70 PORTSMOUTH AVE, STRATHAM, N.H. 03885
PHONE: 603-583-4860, FAX: 603-583-4863

LOCATION
LEGEND
1"=1000'

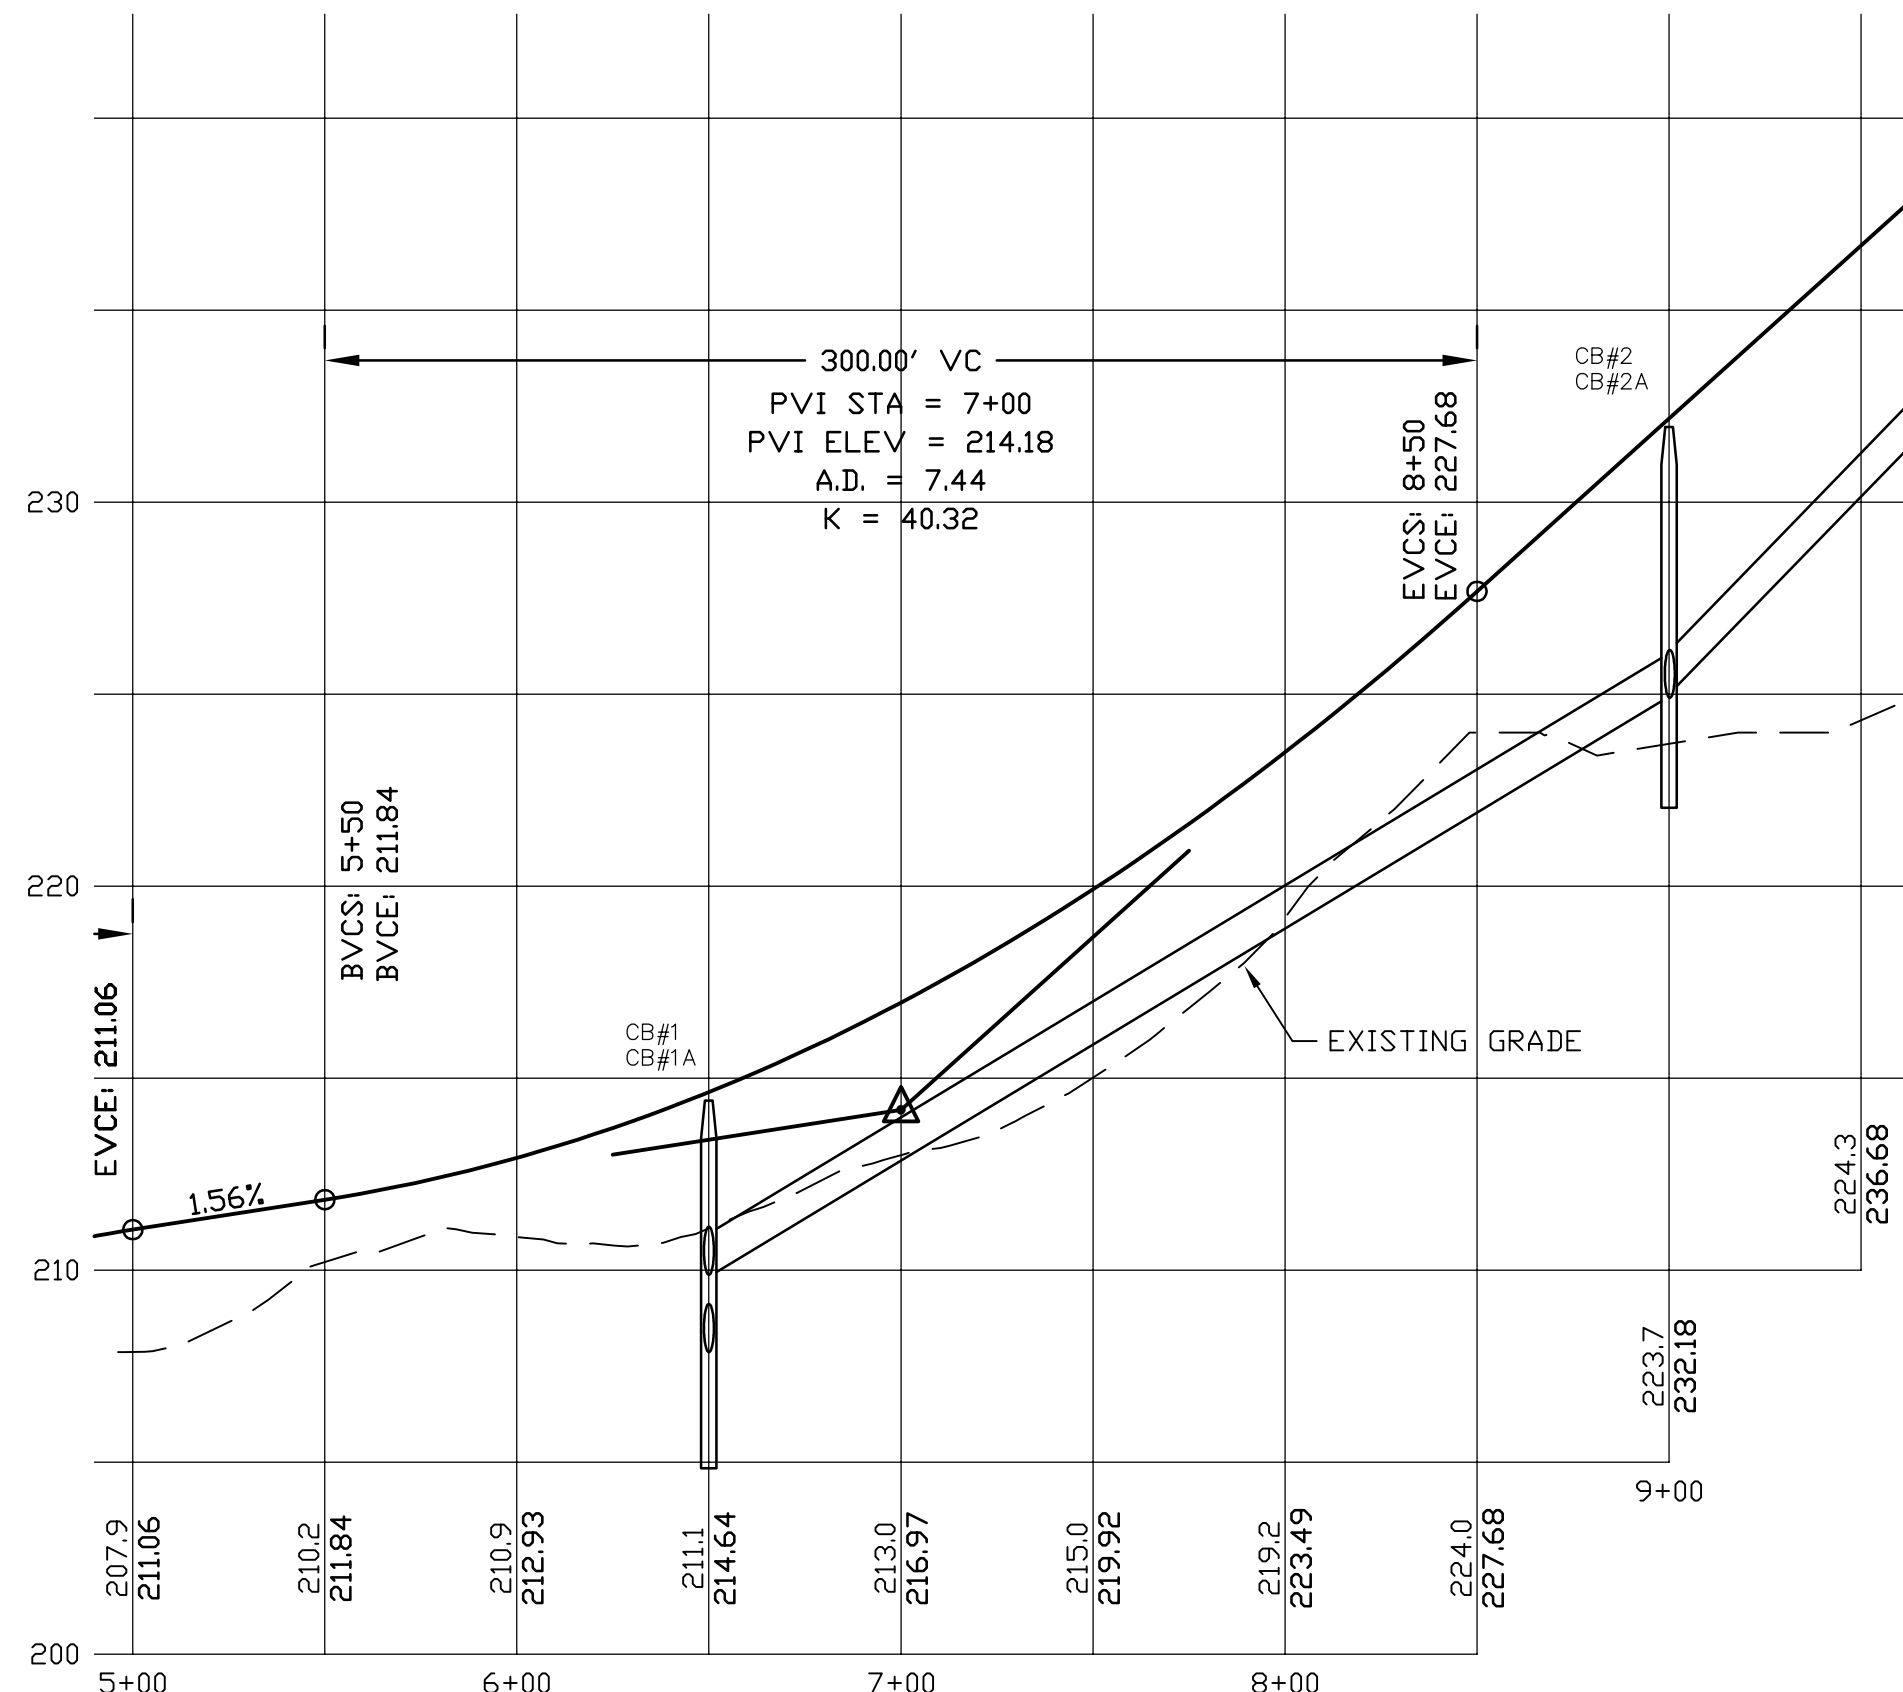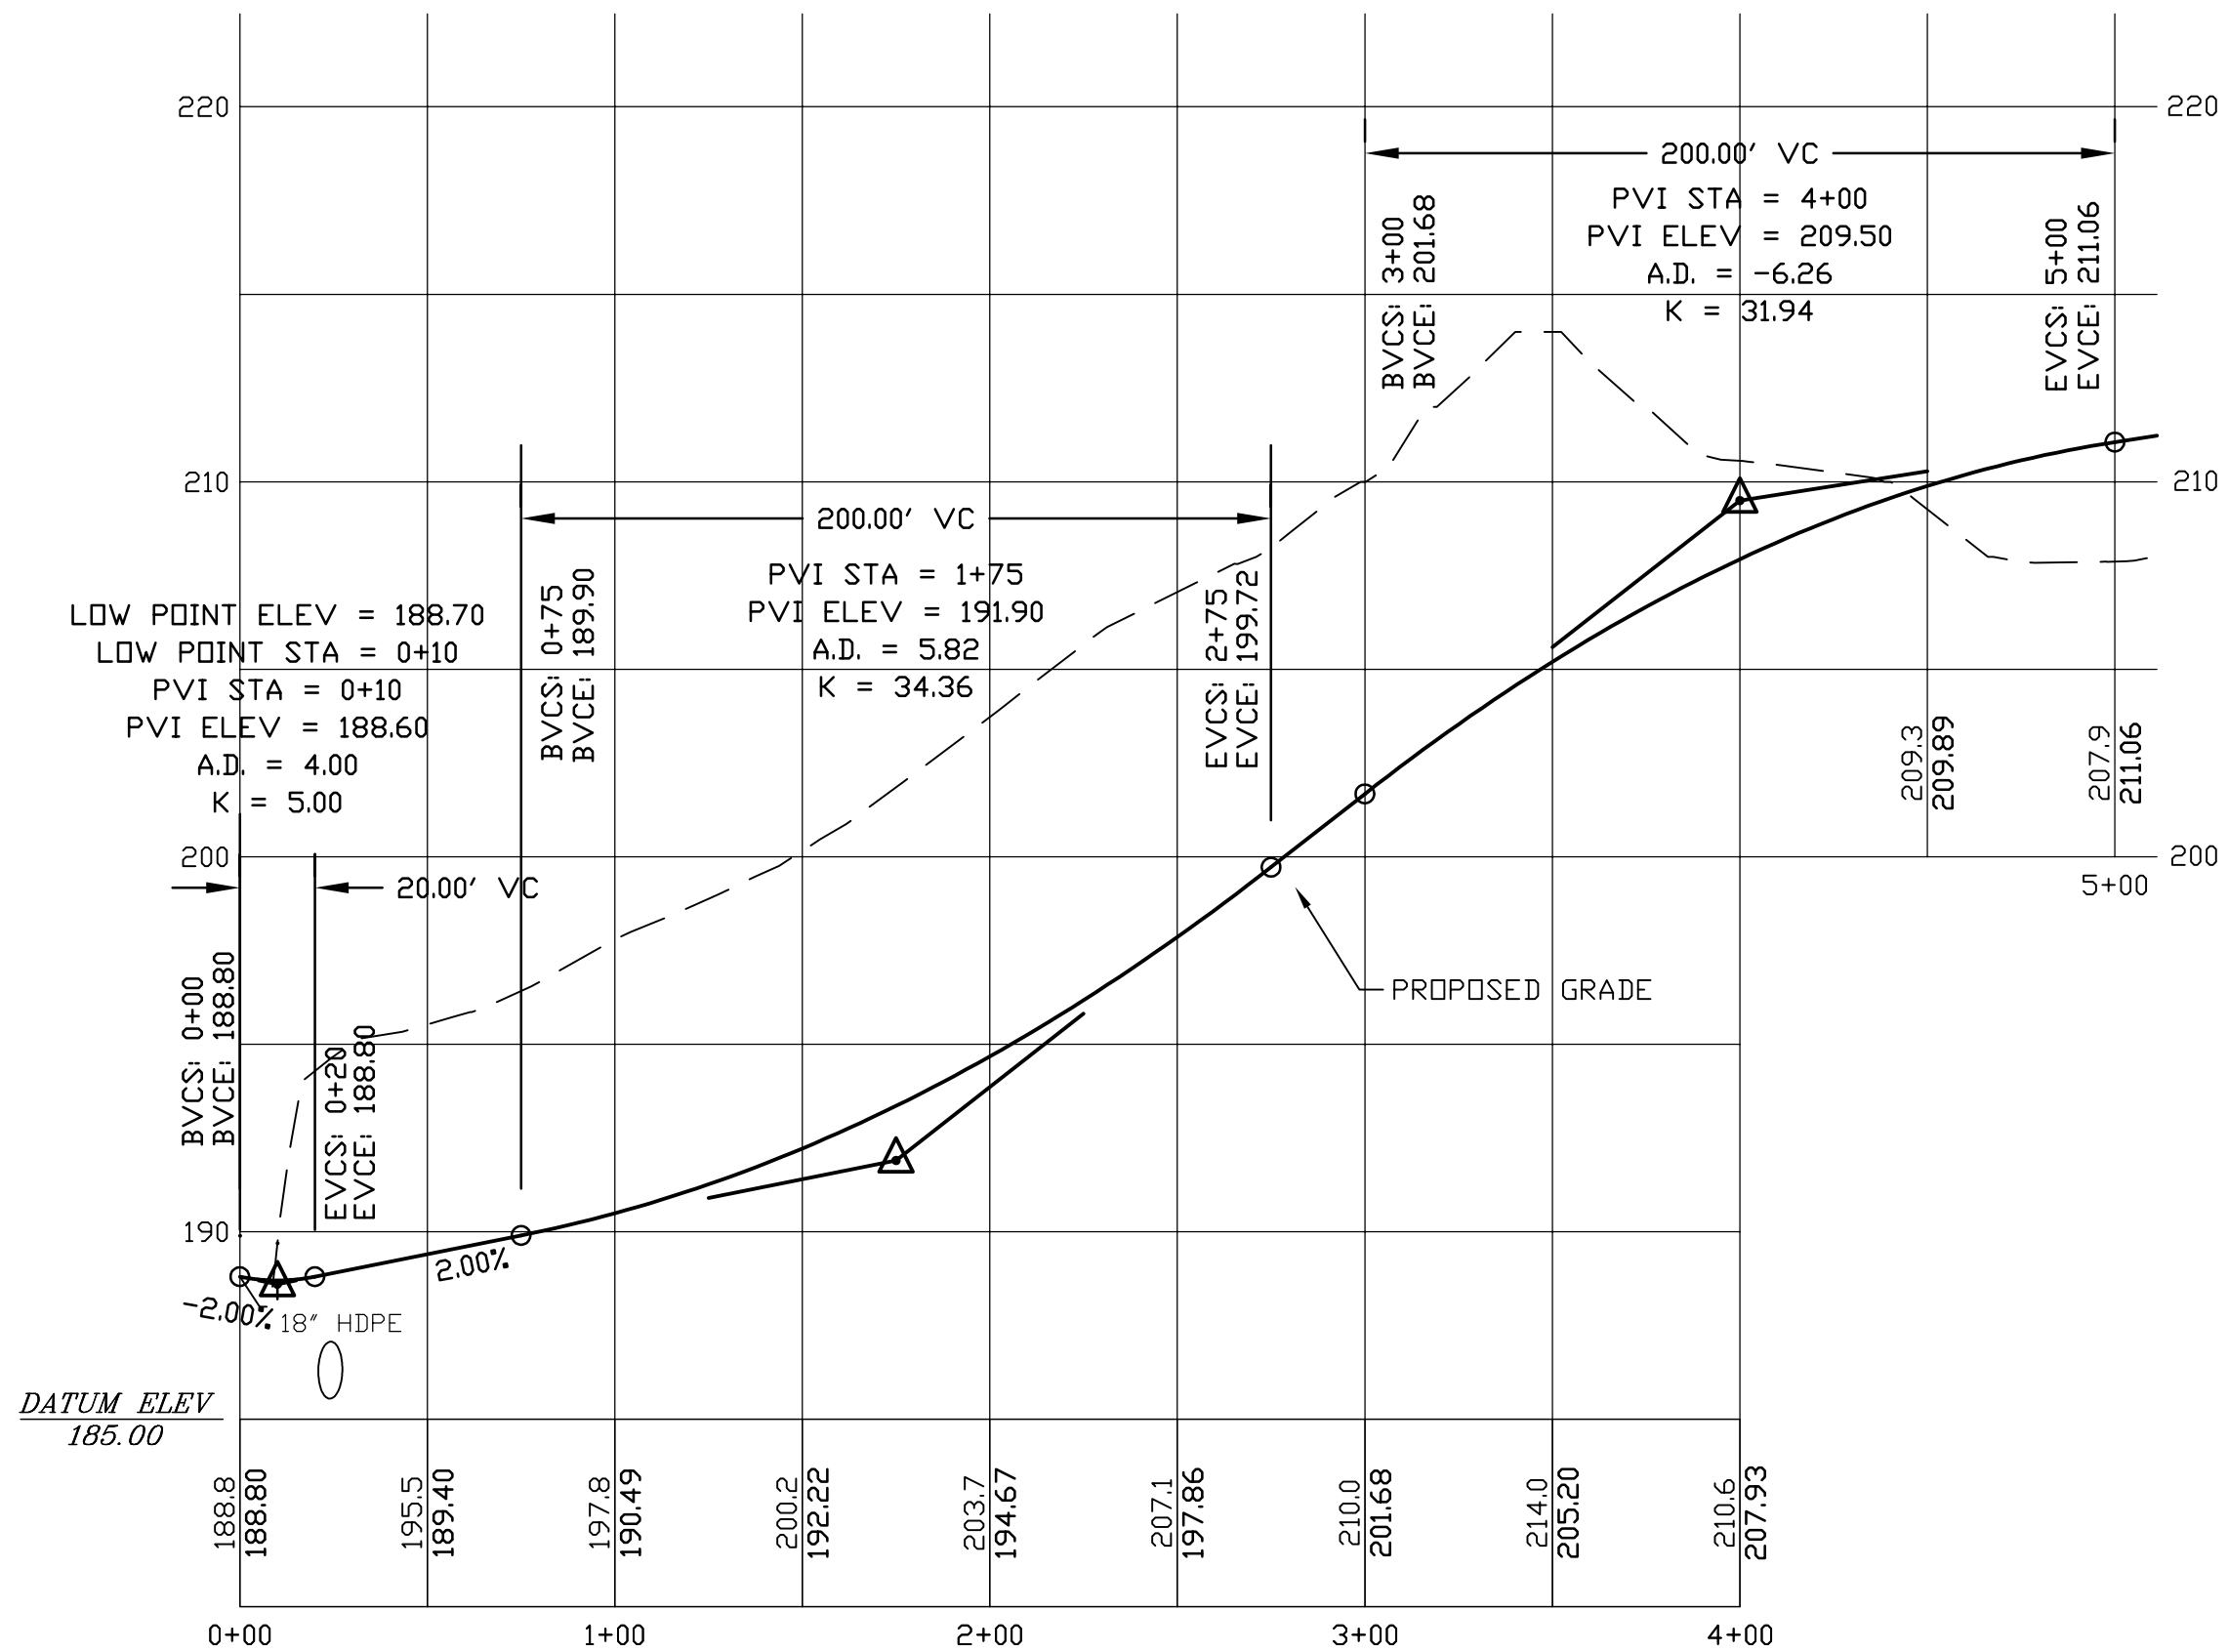

COOPER LIGHTING (OR EQUAL)

STREET LIGHT DETAIL

Luminaire Schedule
TLM-B04-LED-E1-5WQ/ 20' AFG

1. LIGHTING SHALL BE DIRECTED & SHIELDED DOWNWARD TO REDUCE GLARE.

PROFILE SCALES:
HORIZONTAL: 1"=50' VERTICAL: 1"=5'

GRAPHIC SCALE
1 inch = 50 ft.

PER ENGINEERING REVIEW	6-17-12
PER PLANNING BOARD REVIEW	8-1-12
REVISE PER A&T REVIEW	12-10-12
PER CONDITIONAL APPROVAL	3-7-13
PER SITE CONDITION	5-24-13

PLAN & PROFILE - P1

PLAN FOR:
RESIDENTIAL DEVELOPMENT
ROUTE 9
BARRINGTON, NH

DATE: JUNE 2011	SCALE: 1" = 50'
PROJ. NO: NH-634	SHEET NO. 10 OF 20