




RECEIVED  
SEP / 03 2014  
IND USE OFFICE

**MJS**  
**ENGINEERING, PC**

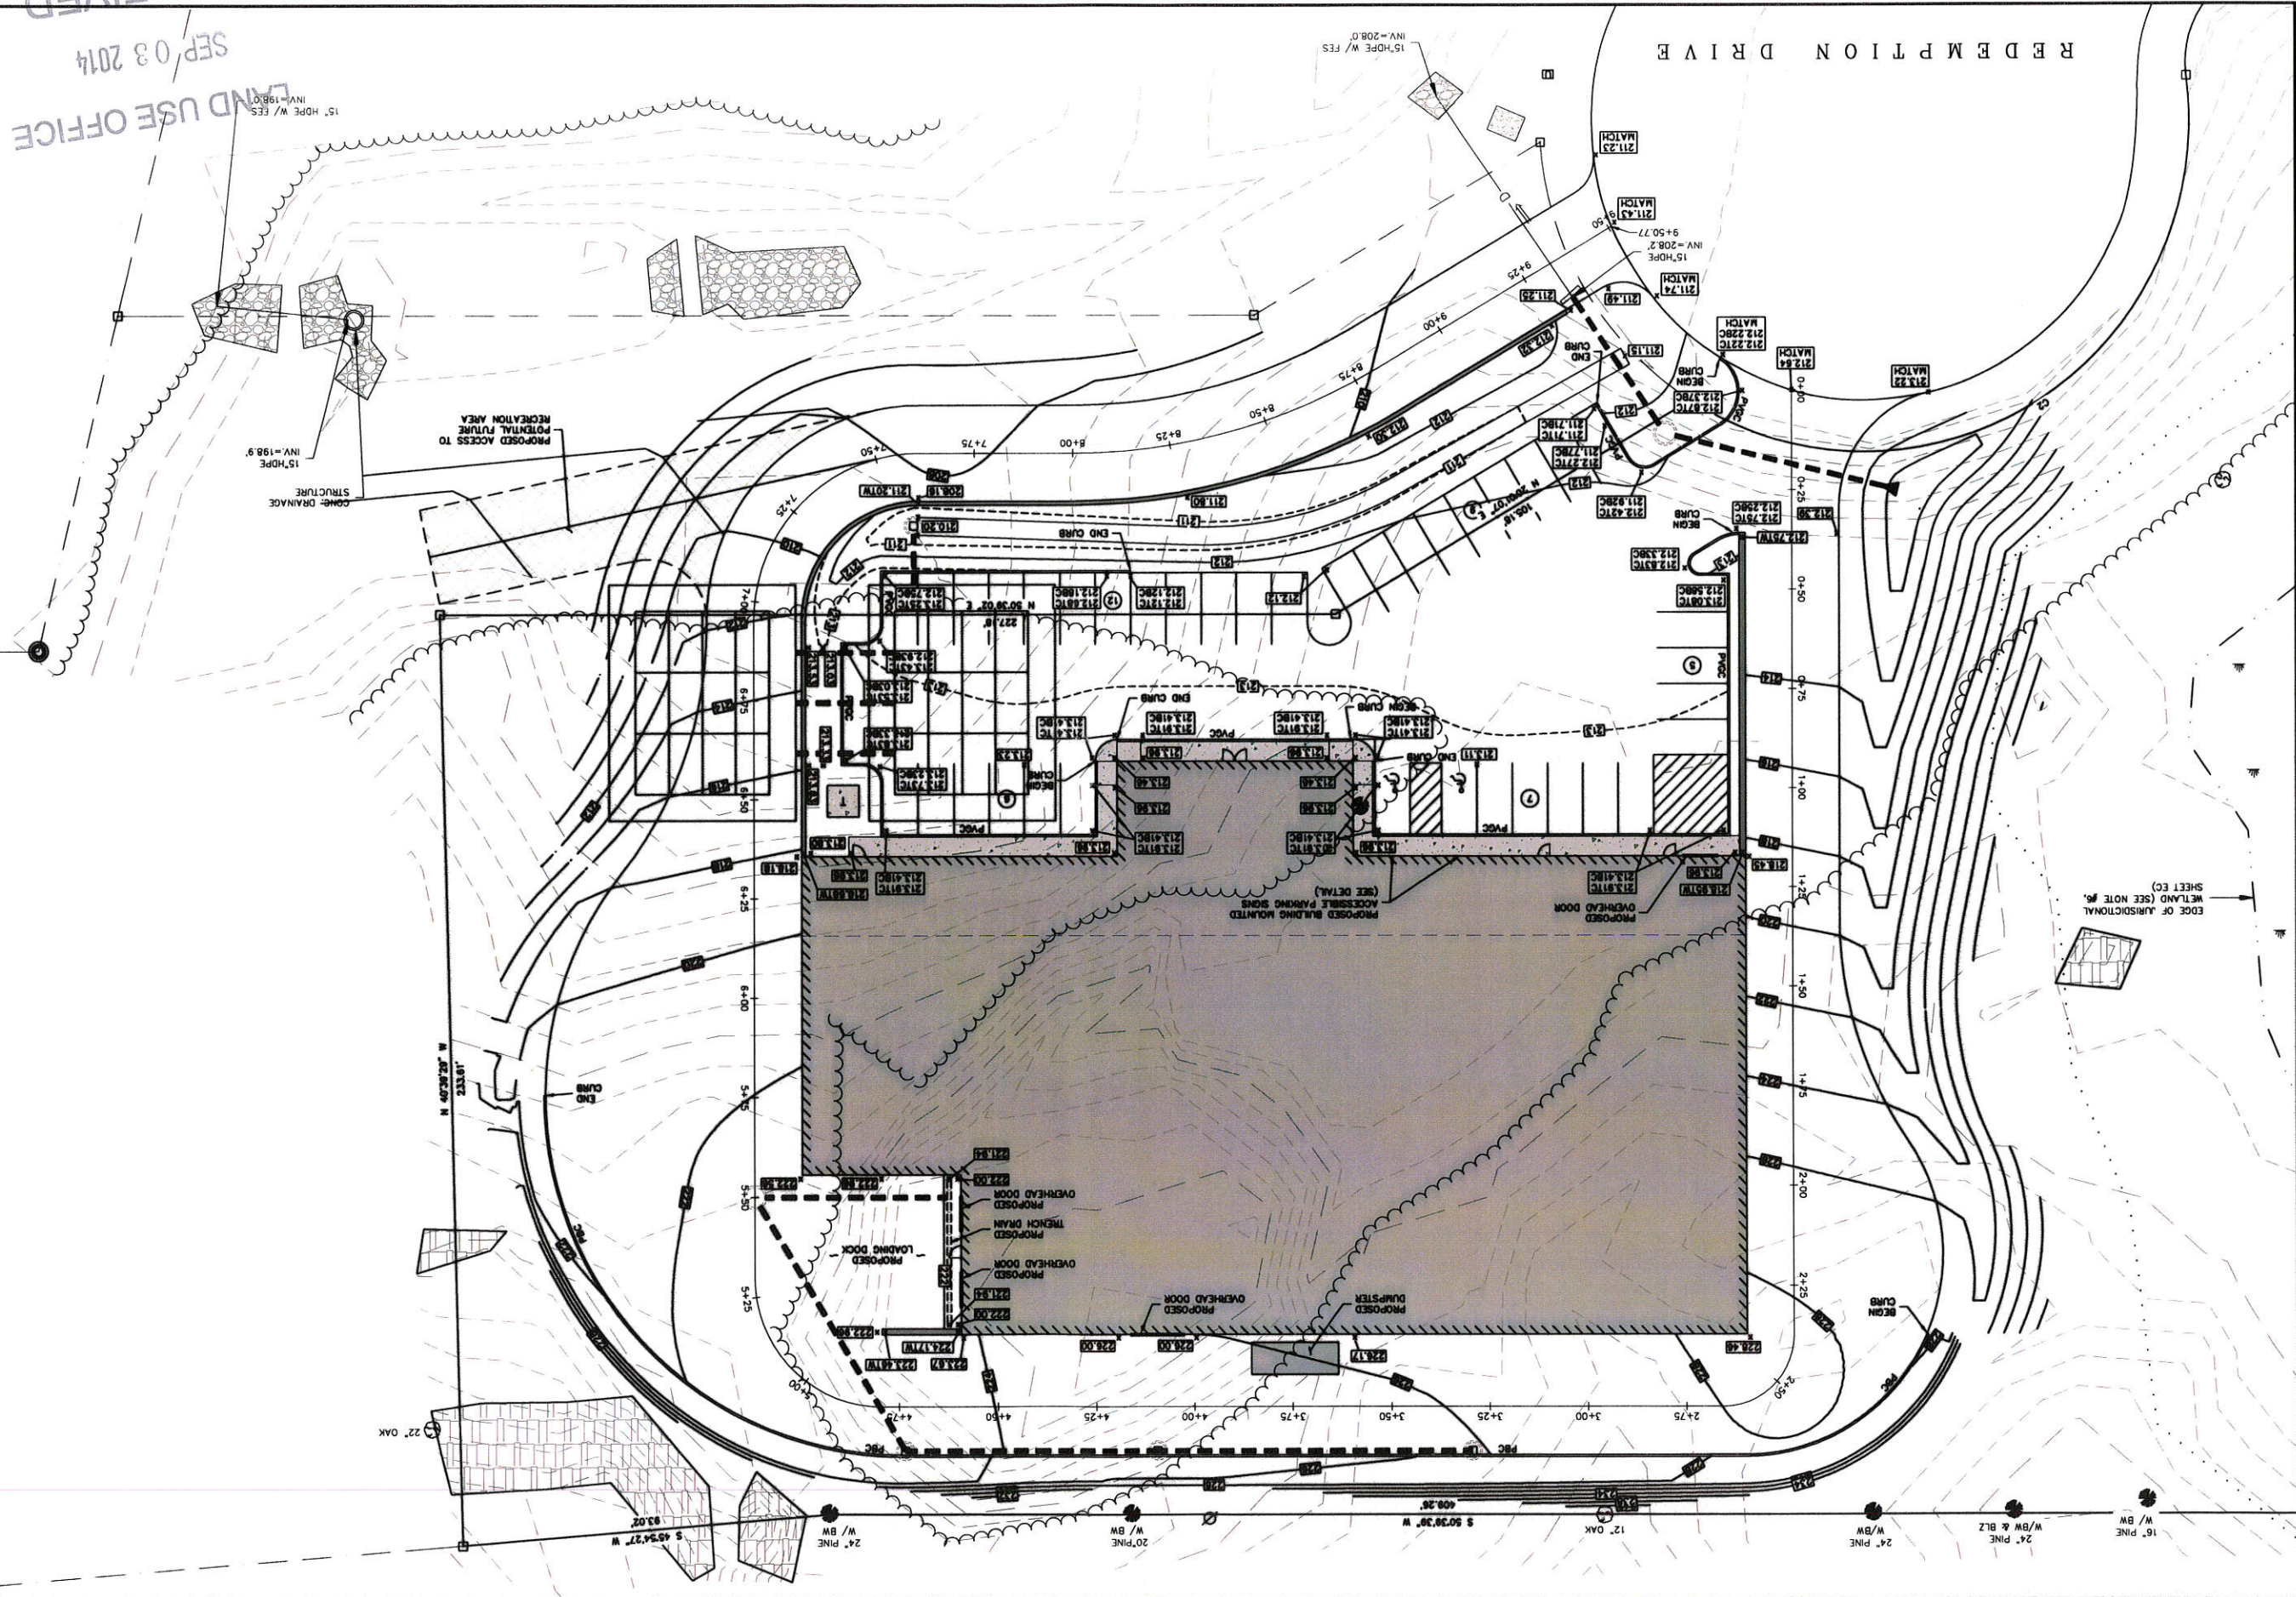

CIVIL  
ENVIRONMENTAL  
CONSULTING ENGINEERING

5 RALPH RD., P.O. Box 359  
Newmarket, NH 03857  
PHONE: (603) 659-4079, FAX (603) 659-4467  
E-MAIL: [ralph@mjsengineering.com](mailto:ralph@mjsengineering.com)

SITE PLAN  
prepared for  
TURBOCAM  
MAP 234, LOT 1.5  
ROUTE 9 BARRINGTON, NH

DATE: 8/20/14  
SCALE: 1"=20'  
DESIGNED BY: JLG/MJS  
DRAWN BY: JLG  
APPROVED BY: MJS  
DWG FILE: 14028C1 - JEFF

SEAL  
CONCEP[illegible]