


BARRINGTON TOWN OFFICES

Ramsdell Lane, Barrington, New
Hampshire 03825

PROGRESS
February 10, 2015

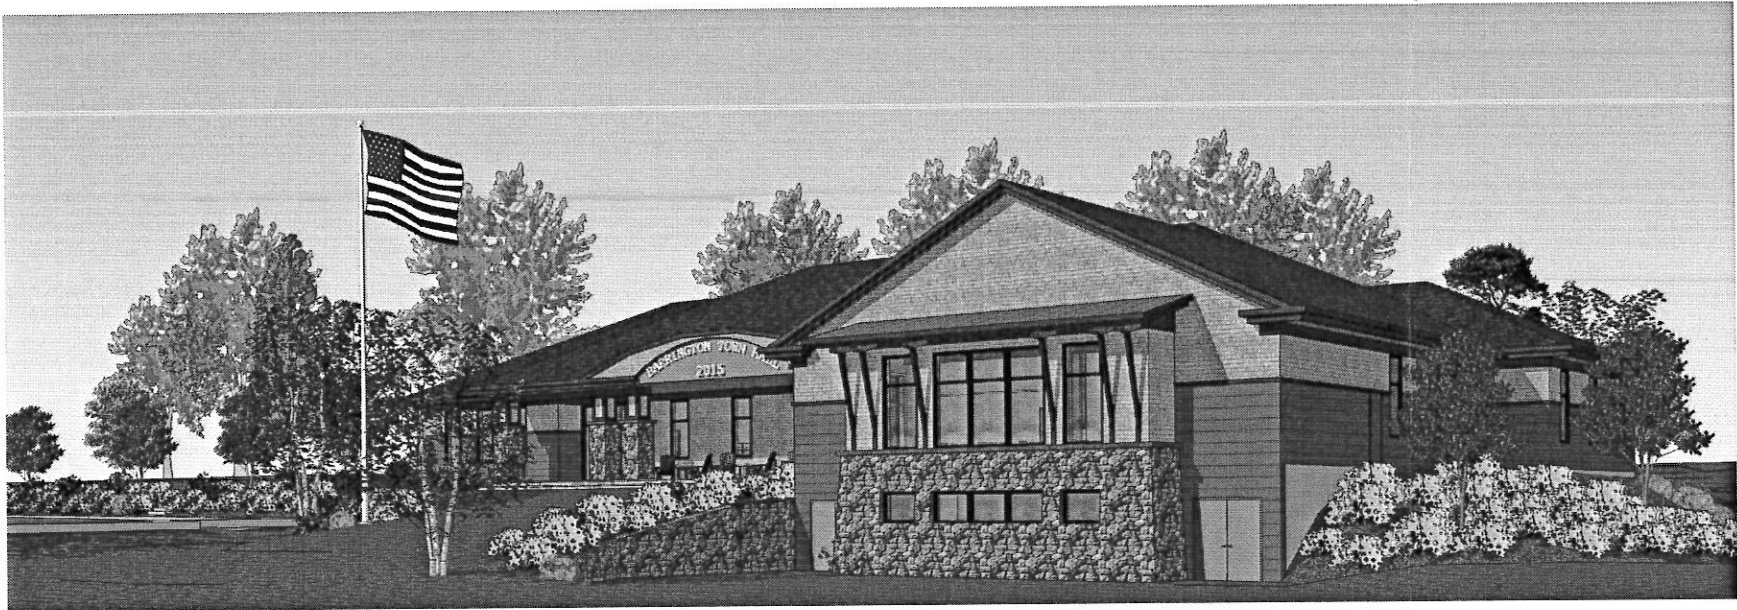

ARCHITECT:
SMP Architecture
30 S. Main St., Building 2
Concord, NH 03301-4809
T: (603) 228-8880
F: (603) 228-8881
Contact: Jason LaCombe

STRUCTURAL ENGINEER:
JSN Engineering
1 Autumn Street
Portsmouth NH 03801
T: (603) 433-8639
Email: hossein@jsneng.com
Contact: Hossein Salehkhoh, P.E.

MECHANICAL ENGINEER:
Kohler and Lewis Engineering
27 Mechanic Street
Keene NH 03431
T: (603) 352-4841
Contact: Adam Kohler P.E.

PLUMBING ENGINEER:
Kohler and Lewis Engineering
27 Mechanic Street
Keene, NH 03431
T: (603) 352-4841
Contact: Roy Swain P.E.

ELECTRICAL ENGINEER:
Swiftcurrent Engineering Services inc.
10 Forest Falls Drive, Unit 4B
Yarmouth ME. 04096
T: (207) 847-9280
F: (207) 847-9281
Email: tim@swiftcurrenteng.com
Contact: Tim Matthews P.E.

CONSTRUCTION MANAGER:
Bonnett Page & Stone
91 Bisson Ave.
Laconia, NH 03246
T: 603-524-3411
F: 603-524-4641
Email: kmcbey@bpsnh.com
Contact: Keith McBey

CIVIL ENGINEER::
Dubois and King
18 Constitution Drive
Bedford NH 03110
T: 603-637-1043
Email: jadler@dubois-king.com
Contact: Jeff Adler P.E.

index of drawings

location map

DRAWING LIST - Civil/Survey		DRAWING LIST - Architectural	
C101	Unnamed	---	COVERSHEET
DRAWING LIST - Landscape		A0.1	CODE ANALYSIS PLANS
S101	Unnamed	AD101	LEVEL 1 DEMOLITION PLAN
		AD102	LEVEL 2 DEMOLITION PLAN
		0	Furniture plan
		A001	GENERAL NOTES, ABBREVIATIONS, ANNOTATIONS LEGENDS, & WALL TYPES
		A1.0	LOWER FLOOR PLAN
		A1.1	MAIN FLOOR PLAN
		A1.2	MAIN FLOOR - REFLECTED CEILING PLAN
		A1.3	ROOF PLAN
		A2.1	EXTERIOR ELEVATIONS
		A3.1	BUILDING SECTIONS
		A3.2	BUILDING SECTIONS
		A4.1	WALL SECTIONS
		A102	LEVEL 2 FLOOR PLAN
		A104	LEVEL 2 REFLECTED CEILING PLAN
		A202	EXTERIOR ELEVATIONS
		A203	INTERIOR ELEVATIONS
		A401	ENLARGED RESTROOM PLANS
		A402	ENLARGED STAIR AND ELEVATOR PLANS AND SECTIONS
		A501	EXTERIOR DETAILS
		A502	INTERIOR DETAILS
		A601	DOOR SCHEDULES
		A602	WINDOW SCHEDULES

DRAWING LIST - Mechanical	
M101	Unnamed

DRAWING LIST - Electrical	
E101	Unnamed
E102	Unnamed

DRAWING LIST - Plumbing	
P101	Unnamed

LAND USE OFFICE
FEB 25 2015
RECEIVED

INDEX OF DRAWINGS

NUMBERING SYSTEM:

DISCIPLINE:
G - GENERAL
C - CIVIL
L - LANDSCAPE
S - STRUCTURAL
A - ARCHITECTURE
I - INTERIORS
Q - EQUIPMENT
F - FIRE
PROTECTION
P - PLUMBING
M - MECHANICAL
ELECTRICAL

01/A101

NUMBER OF PLAN, DETAIL,
ETC. ON SHEET

LEGEND

ANNOTATION CALLOUTS/DRAWING SYMBOLS

	INTERIOR ELEVATION	Room name 101	ROOM TAG A: 150 SF F1 - B1 - W1
	EXTERIOR ELEVATION		WINDOW TYPE
	SECTION		WALL TYPE
	PLAN BLOW-UP DETAIL		GRID / COLUMN LINE DESIGNATOR
	SPOT ELEVATION		CASEWORK TAG
	FLOOR LEVEL & NAME		ACCESSORY TAG
	NORTH ARROW		SHEET KEYNOTE
	DOOR NUMBER TAG		REVISION TAG

CODE SUMMARY

1. PROJECT SUMMARY:

Project is new construction consisting of a one story structure with partial walk-out basement.

2. APPLICABLE CODES INCLUDING, BUT NOT LIMITED TO:

BUILDING CODE: IBC 2009
LIFE SAFETY CODE: NFPA 101, 2009
ENERGY CODE: IBC, 2009
NH BARRIER FREE CODE
NH CODE AMENDMENTS

3. OCCUPANCY/USE GROUPS:

Non-separated Mixed use
- Office areas: B, Business
- Meeting Room: A3, Assembly
- Lower Level: S2, Storage

4. CONSTRUCTION CLASSIFICATION: 5A

5. BUILDING HEIGHT:

PROPOSED BUILDING: 31'-6" (ridge), 1 STORY,
GRADE PLANE: 1'-0" BELOW FIRST FLOOR
BASEMENT: YES (Partial, walk-out)

ALLOWABLE ADJUSTED BUILDING HEIGHT: 50'-0", 1 Story
ALLOWABLE HEIGHT PER TOWN REGULATIONS: 35'-0"

6. BUILDING AREA:

LOWER LEVEL AREA: 1,348 gsf
MAIN LEVEL: 10,472 gsf
TOTAL BUILDING AREA: 11,820 gsf

ALLOWABLE AREA WITH MODIFICATIONS: NOTED BLEOW: 13,800 gsf
- SPRINKLER SYSTEM INCREASE: 0 gsf
- FRONTAGE INCREASE: 20% = 11,500 x 1.2 = 13,800 gsf

7. OCCUPANT CAPACITY:

SEE CODE ANALYSIS KEY PLANS FOR ROOM OCCUPANT LOADS.

OCCUPANT LOAD PER FLOOR:
LOWER LEVEL: 3 Occupants
MAIN LEVEL, OFFICES: 81 Occupants
MAIN LEVEL, ACCESSORY USE STORAGE: 4 Occupants
MAIN LEVEL, MEETING ROOM: 190 Occupants

NOTE: Meeting room use is not concurrent with office occupancy

8. EGRESS/ TRAVEL DISTANCES:

EXITS REQUIRED, BUILDING = 2
EXITS REQUIRED, MEETING RM = 2, When open as 1 room
EXITS REQUIRED, LOWER LEVEL = 2

EGRESS WIDTH: 44 INCHES

ALLOWABLE TRAVEL DISTANCE:
- Office areas: B, Business 200 Feet
- Meeting Room: A3, Assembly 200 Feet
- Lower Level: S2, Storage 200 Feet

ALLOWABLE DEAD END CORRIDOR:
- Office areas: B, Business 20 Feet
- Meeting Room: A3, Assembly 20 Feet
- Lower Level: S2, Storage 50 Feet

ALLOWABLE COMMON PATH OF TRAVEL:
- Office areas: B, Business 75 Feet
- Meeting Room: A3, Assembly 20 Feet (over 50 ppl)
- Lower Level: S2, Storage 50 Feet

9. FIRE RESISTANCE RATINGS:

IBC TABLE 601 AND CHAPTER 7

PRIMARY STRUCTURAL FRAME	1 HOUR
BEARING WALLS, EXTERIOR	1 HOUR (INTERIOR SIDE ONLY PER 705.5)
BEARING WALLS, INTERIOR	1 HOUR
EXTERIOR PARTITIONS	0 HOUR BASED ON FIRE SEPARATION
INTERIOR PARTITIONS	0 HOUR
FLOOR CONSTRUCTION	1 HOUR
ROOF CONSTRUCTION	1 HOUR
CORRIDORS	- HOUR
MECHANICAL ROOMS	- HOUR
STORAGE ROOMS	
FIRE WALLS	0 HOUR
FIRE BARRIERS	0 HOUR
SHAFT ENCLOSURES	1 HOUR
FIRE PARTITIONS	0 HOUR
SMOKE BARRIERS	- HOUR
SMOKE PARTITIONS	- HOUR
HORIZONTAL ASSEMBLIES	- HOUR
DRAFTSTOPPING REQUIREMENTS	N/A
- CONCEALED SLEEPER SPACES	N/A
- IN FLOORS	REQUIRED - 3,000 SF MAX AREA
- IN ATTICS	

10. OPENING PROTECTIVES:

REQUIRED

11. INTERIOR FINISHES:

WALL AND CEILING FINISHES - TABLE 803.9
- EXIT ENCLOSURES CLASS A
- CORRIDORS CLASS A
- LOBBIES CLASS B
- ROOMS CLASS C

12. FIRE PROTECTION SYSTEMS:

SPRINKLER SYSTEM REQUIRED? NO
SPRINKLER SYSTEM PROVIDED? NO
PORTABLE FIRE EXTINGUISHERS YES
- MAXIMUM FLOOR AREA 11,250 SF
- MAX. TRAVEL DISTANCE 75 FEET


13. ACCESSIBILITY:

TOWN OFFICE REQUIRED TO BE FULLY ACCESSIBLE
RAMPS:
1:12 MAX. SLOPE WITH HANDRAILS EACH SIDE
1:20 MAX SLOPE WITH NO HANDRAILS


DOORS:
- 36" WIDE MIN. (32" CLEAR SPACE WHEN OPEN 90 DEGREES)
- 18" CLEAR WIDTH FROM LATCH ON PULL SIDE
- 12" CLEAR WIDTH FROM LATCH ON PUSH SIDE
- POWER OPERATORS WITH PUSH BUTTONS REQUIRED AT EXTERIOR OF VESTIBULE DOORS

RESTROOMS:
- SINGLE USE ROOMS ALL REQUIRED TO BE ACCESSIBLE
- 60" DIAMETER CLEAR FLOOR SPACE
- CLEAR SPACE AT FIXTURES
- DOORS MAY SWING INTO ROOM (SECTION 603.2.3 EXC. 2)
SERVICE WINDOWS:
- PARALLEL APPROACH IS ACCEPTABLE
- 36" LONG COUNTER
- COUNTER TO BE 36" MAX. AFF
- 30x48" CLEAR FLOOR SPACE (SECTION 305)


MEETING ROOM:
- 75 SEATS - 4 WHEELCHAIR SPACES ARE REQUIRED (221.2.1)

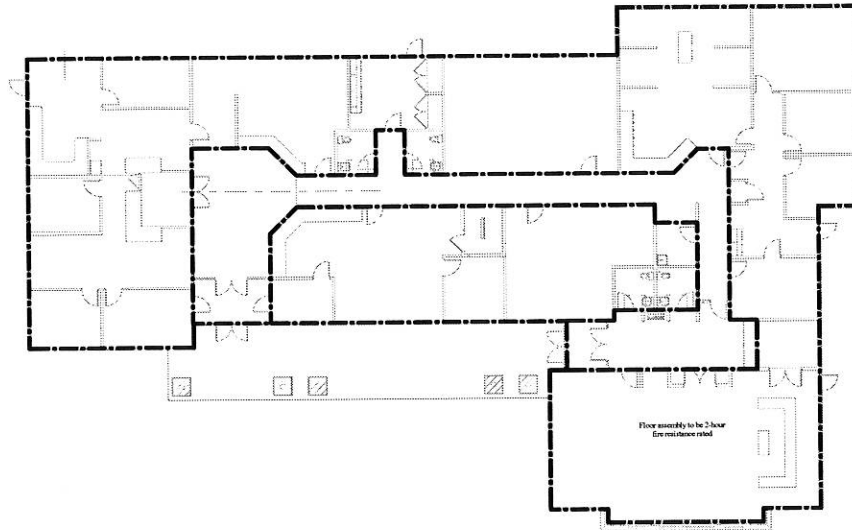

3 MAIN FLOOR - CODE ANALYSIS PLAN - INSULATED CONCRETE FORMS
Scale: 1/16" = 1'-0"

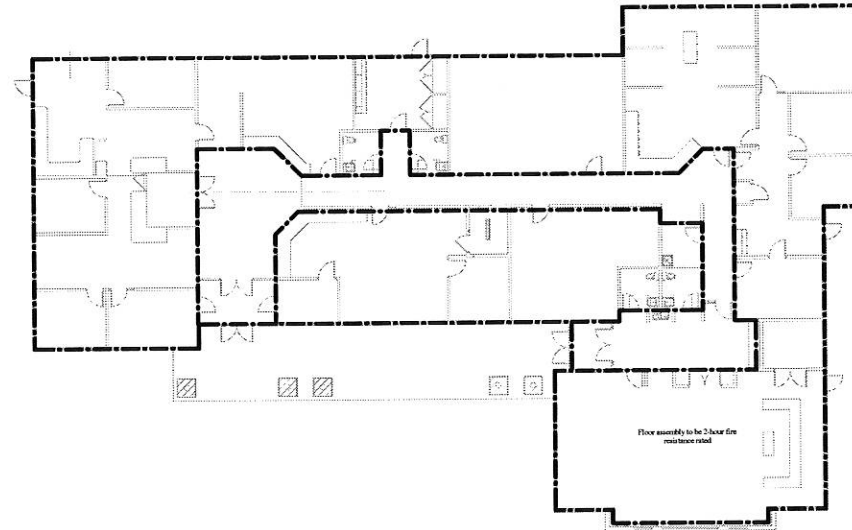

2 MAIN FLOOR - CODE ANALYSIS PLAN
Scale: 1/16" = 1'-0"

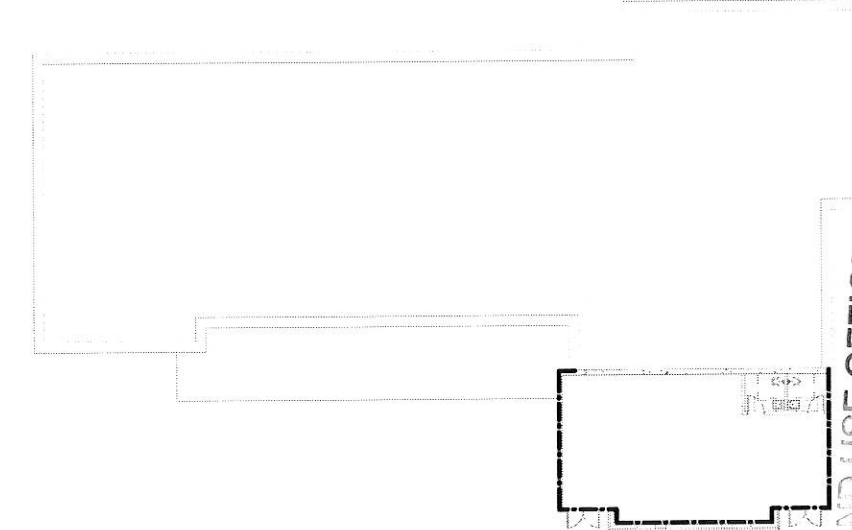

1 LOWER FLOOR - CODE ANALYSIS PLAN
Scale: 1/16" = 1'-0"

PHONE: 603.228.8880
FAX: 603.228.8881
WWW.SMP-ARCH.COM

smp
ARCHITECTURE

BARRINGTON TOWN OFFICES

Ramsdell Lane, Barrington, New Hampshire 03825

CODE ANALYSIS PLANS

PROJECT: BARRINGTON TOWN OFFICES

ISSUED: PROGRESS

JOB NO: 1312

DRAWN BY:

CHECKED BY: Checker

DATE: February 10, 2015

REVISION

DATE

REVISION

DATE

REVISION

DATE

REVISION

DATE

REVISION

DATE

REVISION


DATE

REVISION

DATE

A0.1

© 2015 SMP ARCHITECTURE

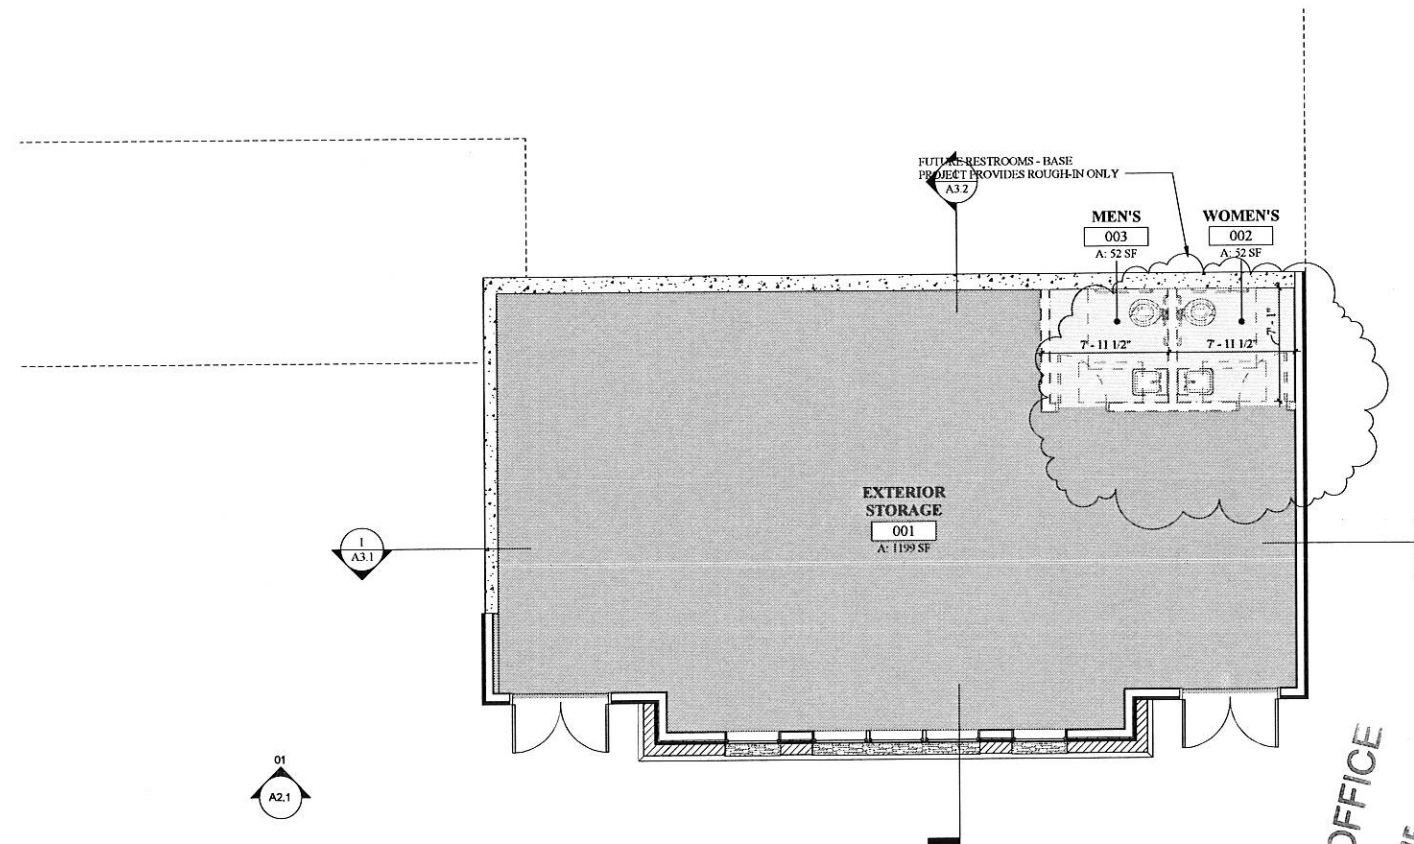

01 LOWER FLOOR PLAN
Scale: 3/16" = 1'-0"

LAND USE OFFICE
FEB 25 2015
RECEIVED

DRAWINGS & SPECS FOR COORDINATION PURPOSES AND TO ENSURE THAT ALL SCOPE OF WORK IS INCLUDED.

BARRINGTON TOWN OFFICE
Ramsdell Lane, Barrington, New Hampshire 03825

LOWER FLOOR PLAN

PROJECT: _____

ISSUED:	PROGRESS
---------	----------

JOB NO:	1312
---------	------

DRAWN BY: Author

CHECKED BY: <u>Checker</u>

DATE: February 10, 2015

REVISION	DATE
1	Date 1

S, CAP		

THE GO		
--------	--	--

FTS		
-----	--	--

NOT		

	SHEET NUMBER:	


[illegible]

A10

A1.0


[illegible]

© 2015 SMP ARCHITECTURE

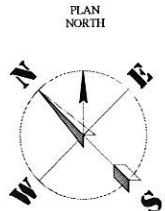

AND USE OFFICE
FEB 25 2015
RECEIVED

© 2015 S&P ARCHITECTURE

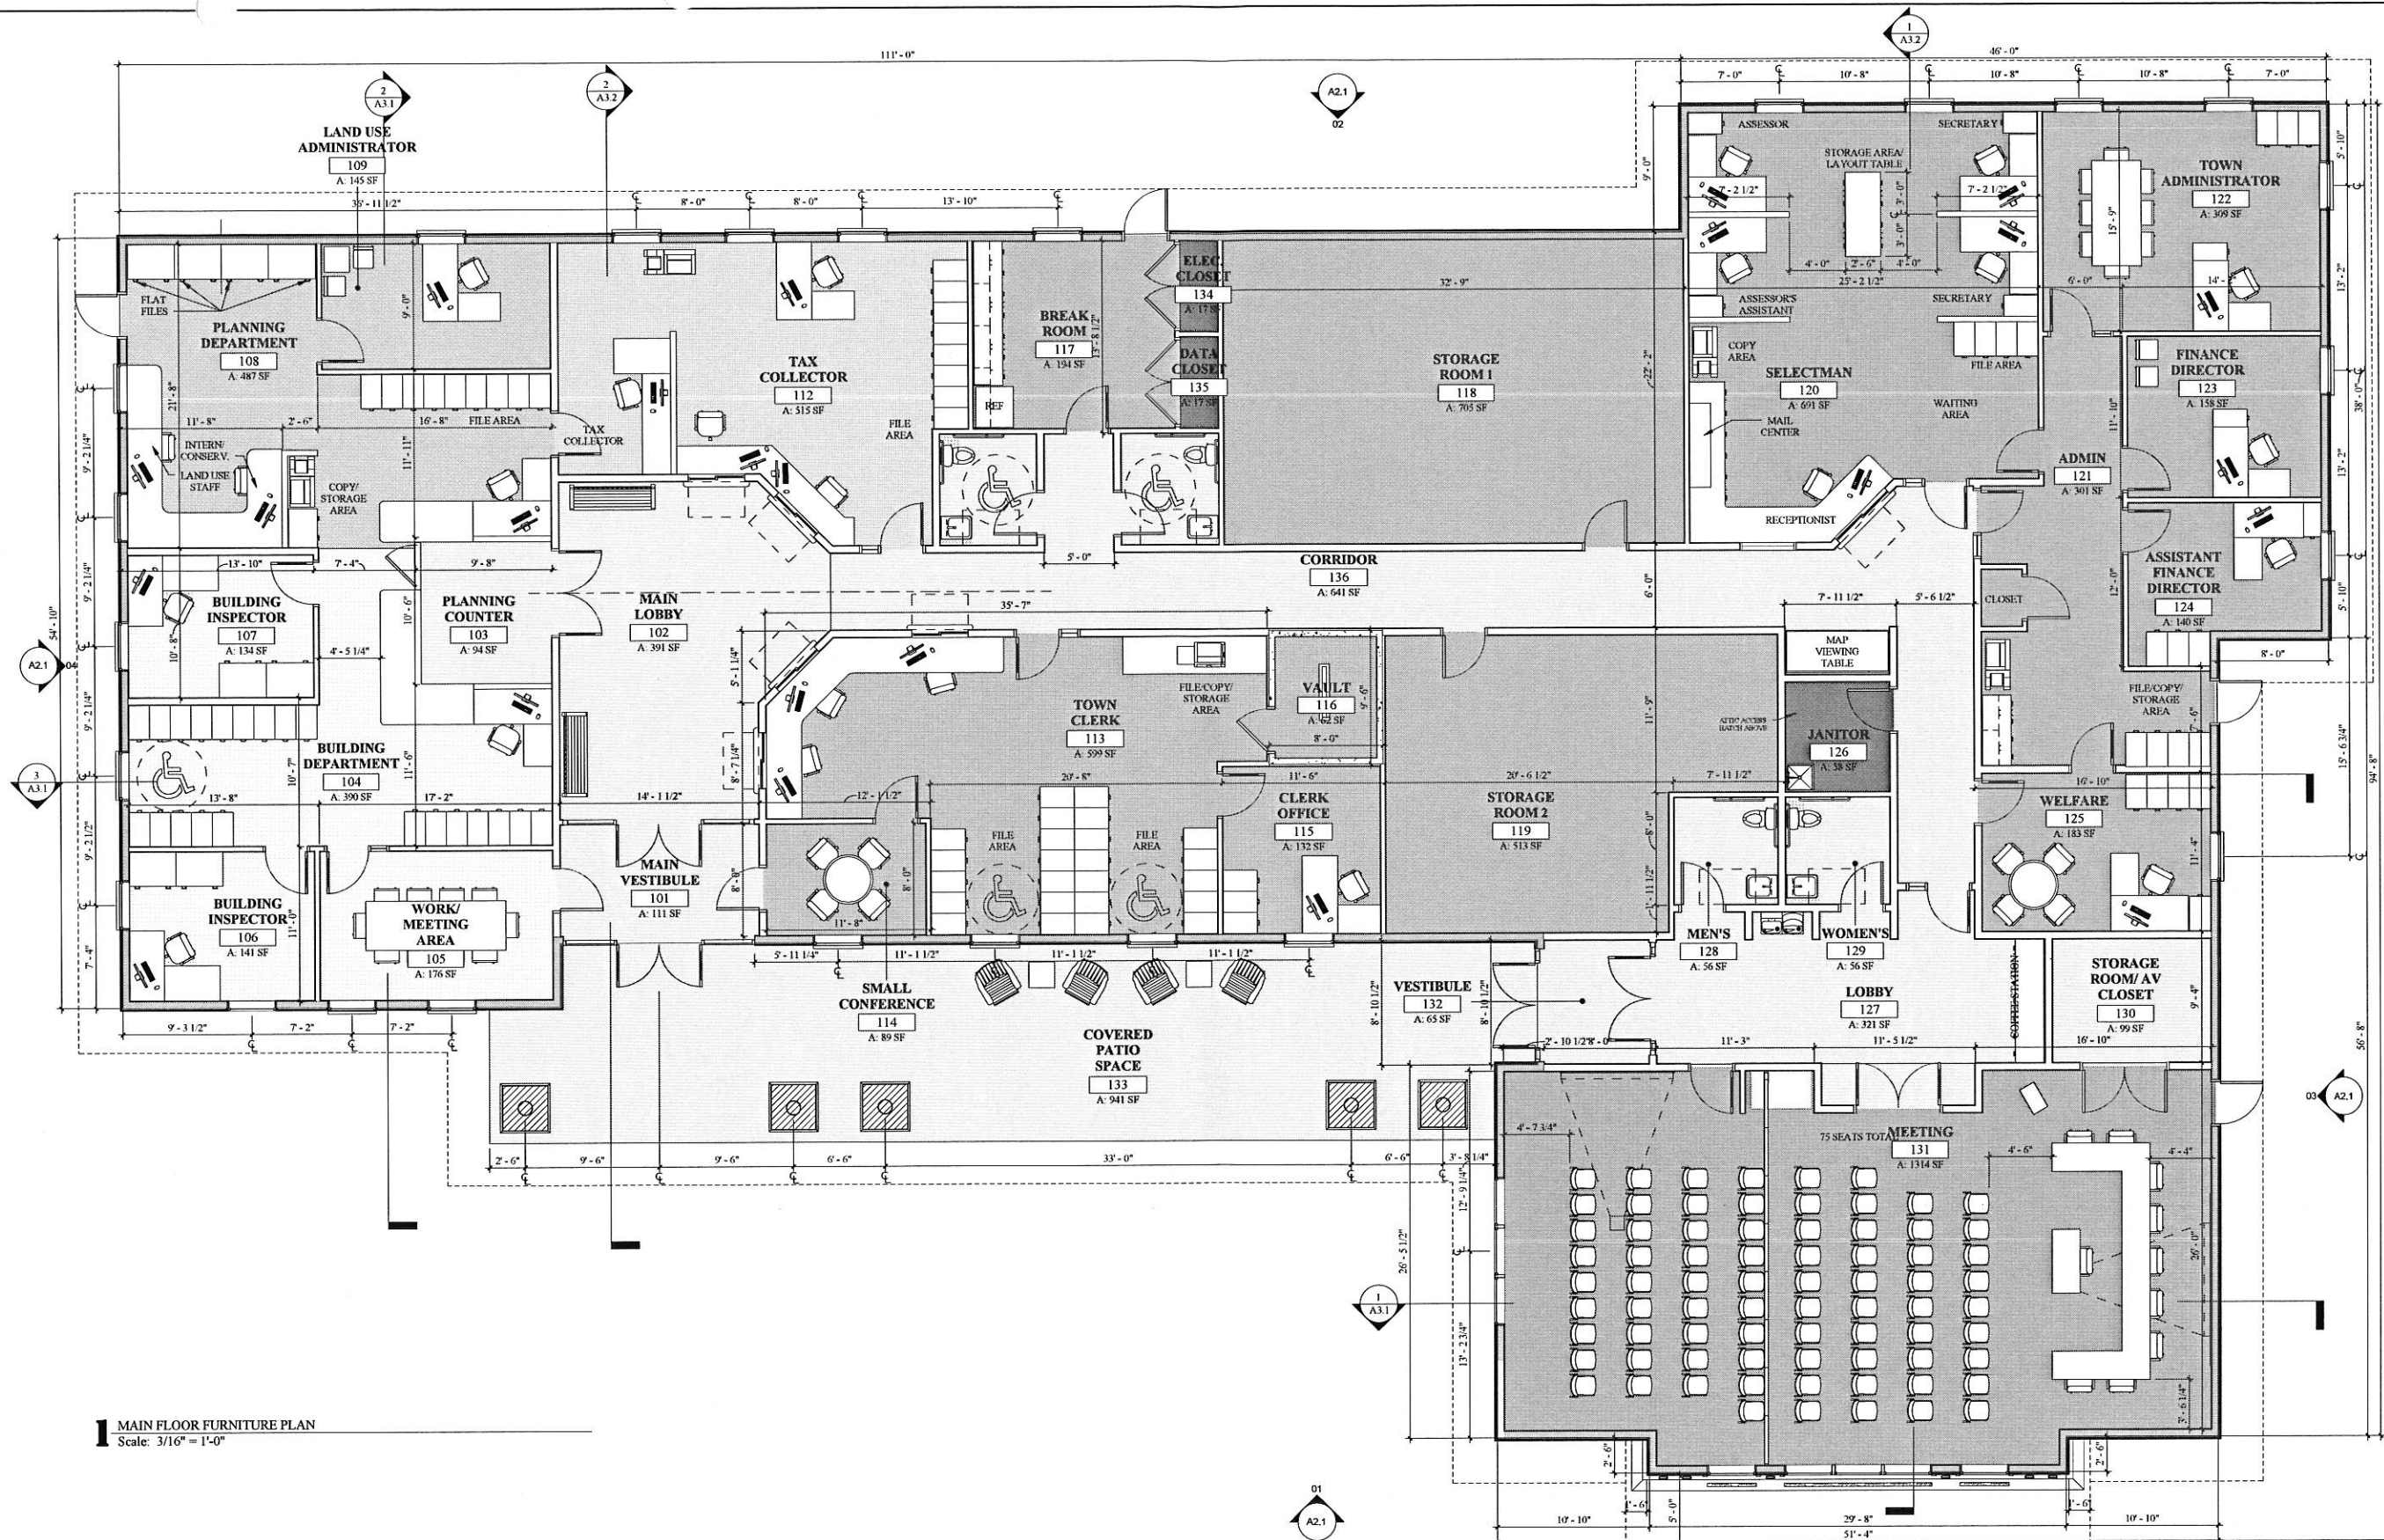

1 MAIN FLOOR FURNITURE PLAN
Scale: 3/16" = 1'-0"

BARRINGTON TOWN OFFICES

Ramsdell Lane, Barrington, New Hampshire 03825

February 10, 2015




THE CARRIAGE HOUSE
30 S. MAIN ST., BUILDING TWO
CONCORD, NH 03301
603.228.8880

LAND USE OFFICE

FEB 25 2015

RECEIVED

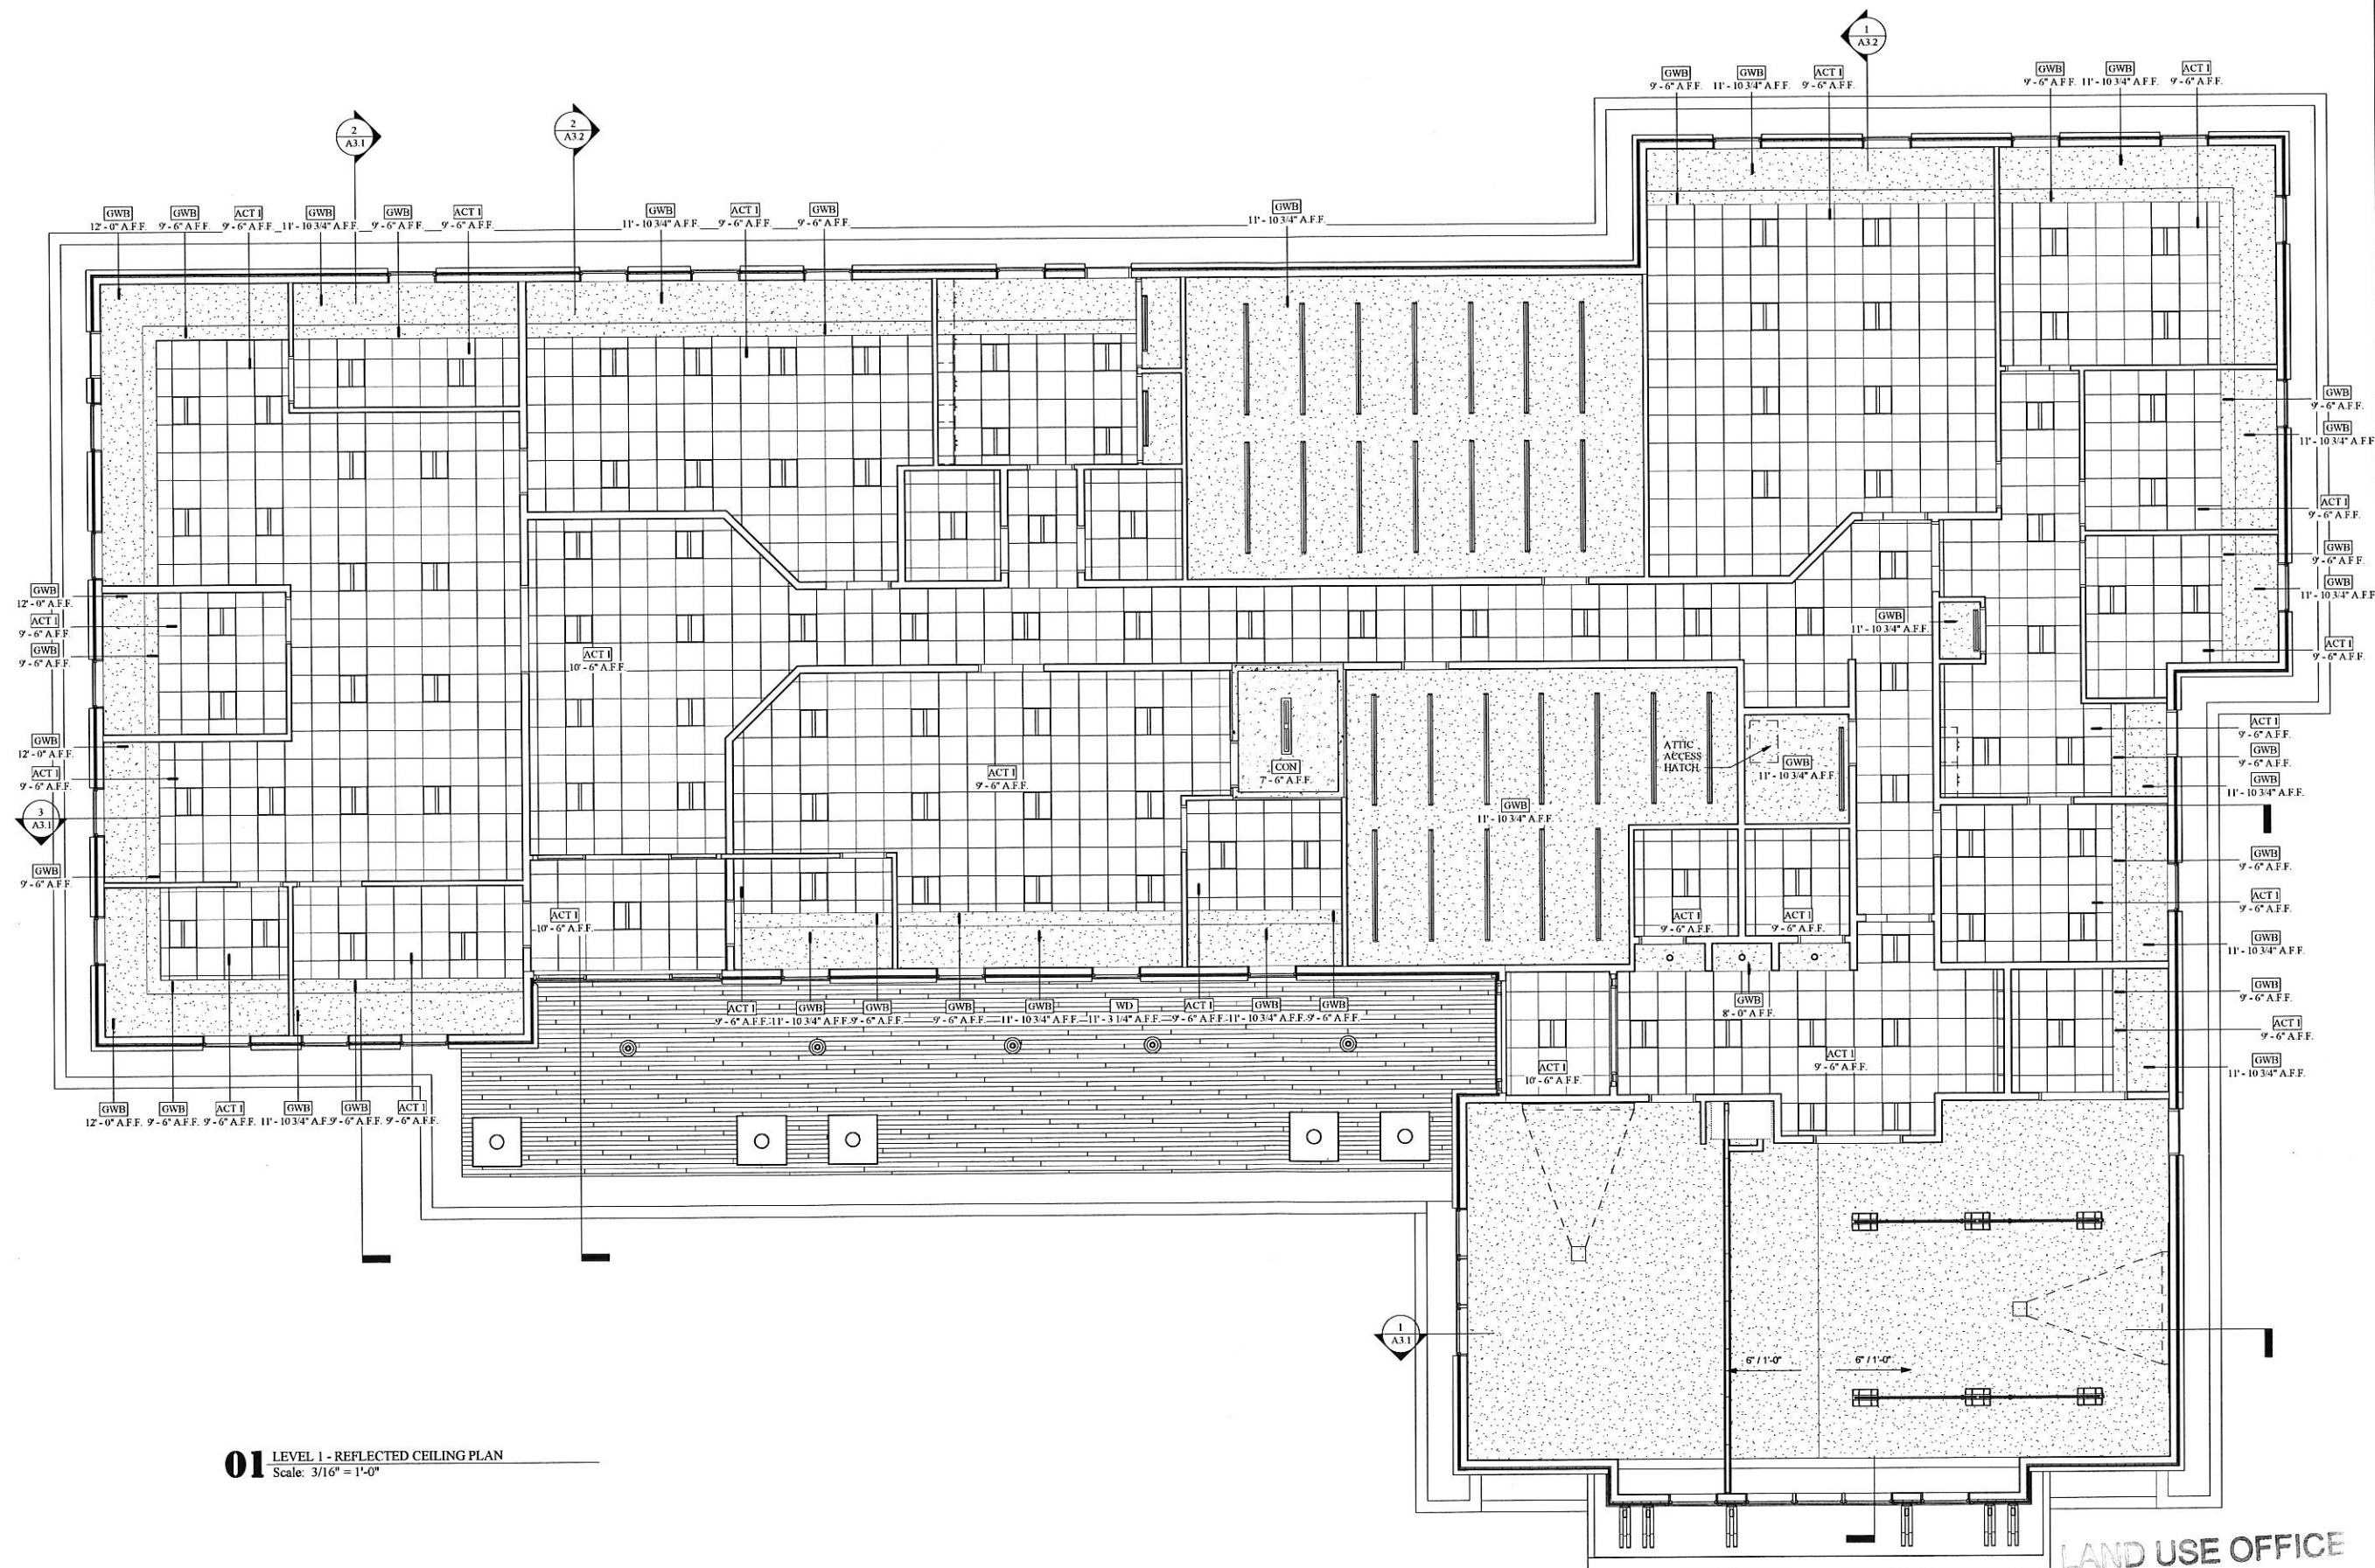

01 LEVEL 1 - REFLECTED CEILING PLAN
Scale: 3/16" = 1'-0"

LAND USE OFFICE

FEB 25 2015

RECEIVED

PHONE: 603.228.8880
FAX: 603.228.8881
WWW.SHEERA.COM



BARRINGTON TOWN OFFICES

Ramsdell Lane, Barrington, New Hampshire 03825

MAIN FLOOR - REFLECTED CEILING PLAN

DRAWING TITLE:

PROJECT:

ISSUED:	PROGRESS
---------	----------

JOB NO:	1312
---------	------

DRAWN BY:	CV
-----------	----

CHECKED BY:	JL
-------------	----

DATE: February 10, 2015

REVISION	DATE

ITIS		


NOTES		

SHEET NUMBER:		

© 2006 The Authors

A1.2

© 2015 SMP ARCHITECTURE

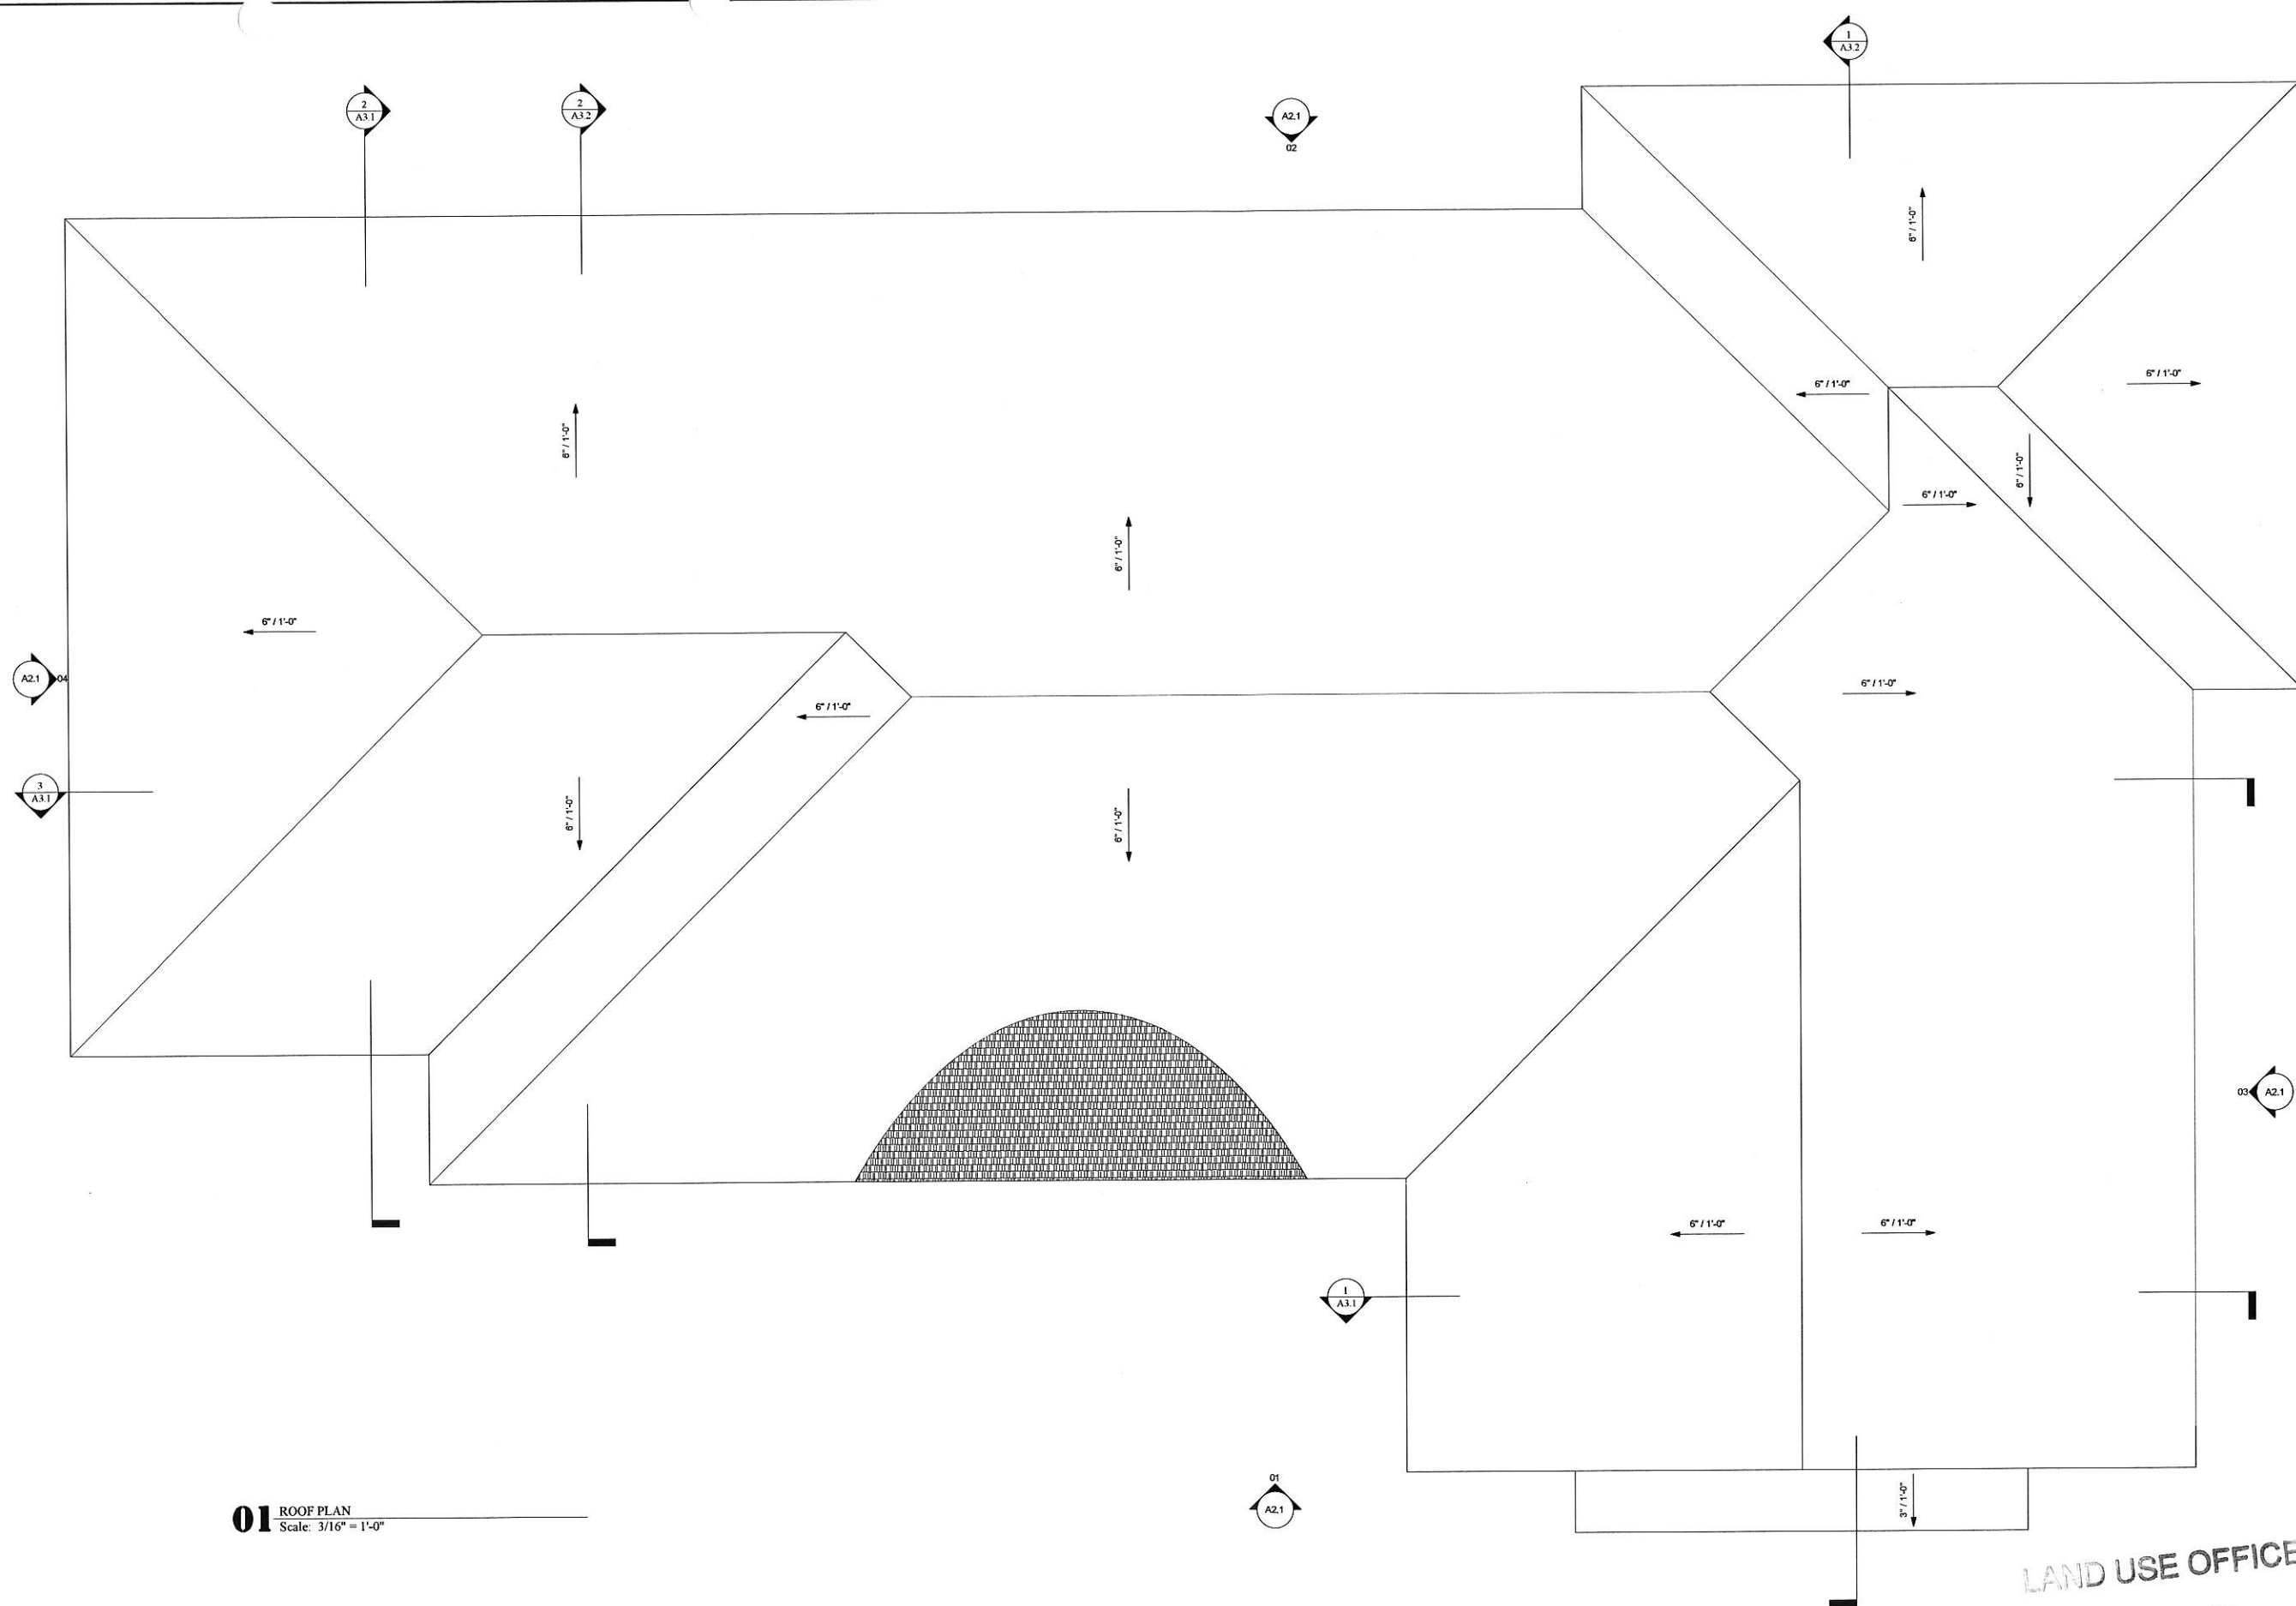

01 ROOF PLAN
Scale: 3/16" = 1'-0"

LAND USE OFFICE
FEB 25 2015
RECEIVED

PHONE: 603.228.8880
FAX: 603.228.8881
WWW.SHEERA.COM



BARRINGTON TOWN OFFICES

Ramsdell Lane, Barrington, New Hampshire 03825

ROOF PLAN

PROJECT:

ISSUED:	PROGRESS
---------	----------

JOB NO: 1312

DRAWN BY: CV

CHECKED BY: _____ Checker

DATE: February 10, 2015

REVISION	DATE

THE GOOD		

IT IS		
-------	--	--


NOT		
-----	--	--

	SHEET NUMBER:
--	---------------

A1.3

© 2015 SMP ARCHITECTURE

2/10/2015 3:35:05 PM C:\Users\JLacomb\Documents\Barrington Town Hall Concept\1_1a\Combae.rvt

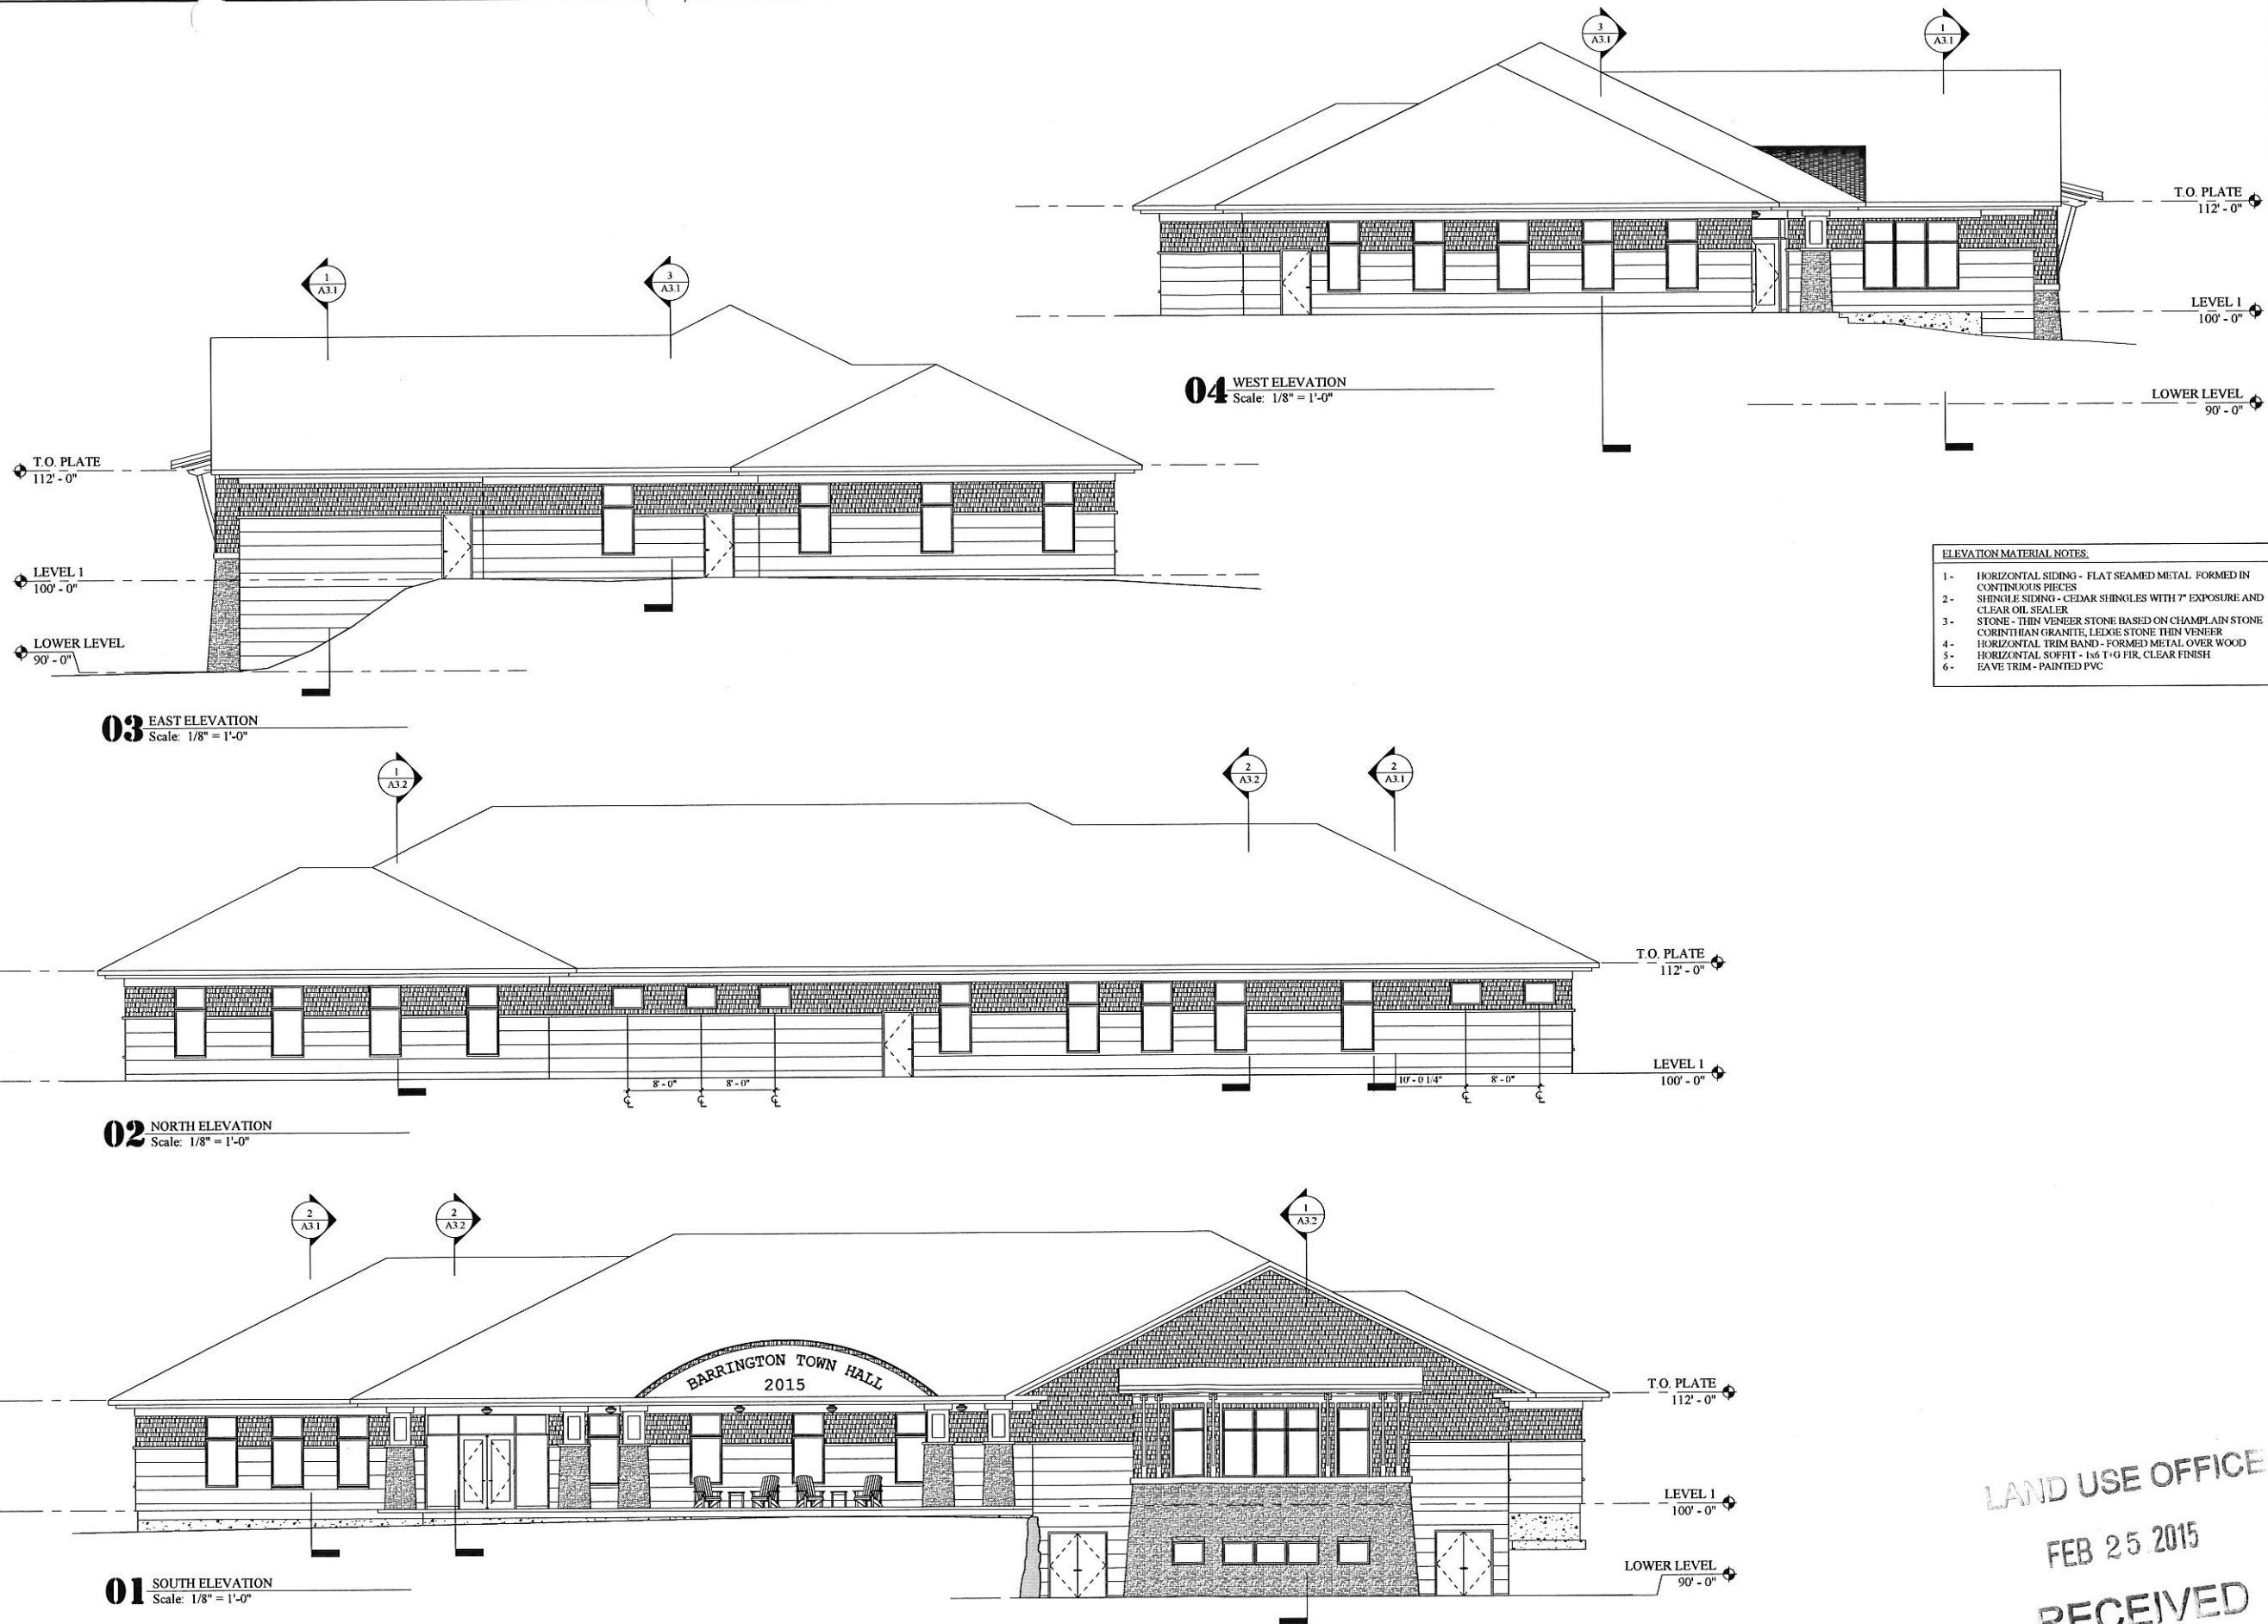

- ELEVATION MATERIAL NOTES:
- 1- HORIZONTAL SIDING - FLAT SEAMED METAL FORMED IN CONTINUOUS PIECES
 - 2- SHINGLE SIDING - CEDAR SHINGLES WITH 7" EXPOSURE AND CLEAR OIL SEALER
 - 3- STONE - THIN VENEER STONE BASED ON CHAMPLAIN STONE CORINTHIAN GRANITE, LEDGE STONE THIN VENEER
 - 4- HORIZONTAL TRIM BAND - FORMED METAL OVER WOOD
 - 5- HORIZONTAL SOFFIT - 1x6 T&G FIR, CLEAR FINISH
 - 6- EAVE TRIM - PAINTED PVC

LAND USE OFFICE
FEB 25 2015
RECEIVED

PHONE: 603.228.8880
FAX: 603.228.8881
WWW.SMP-ARCH.COM

smp
ARCHITECTURE

BARRINGTON TOWN OFFICES

Ramsdell Lane, Barrington, New Hampshire 03825

EXTERIOR ELEVATIONS

NOTE: IT IS THE G.C.'S, C.A.S. AND SUB-CONTRACTOR'S RESPONSIBILITY TO REVIEW ALL DRAWINGS & SPECS FOR CONFORMANCE PURPOSES AND TO ENSURE THAT ALL SCOPE OF WORK IS INCLUDED.

PROJECT:

ISSUED: PROGRESS

JOB NO: 1312

DRAWN BY: Author

CHECKED BY: Checker

DATE: February 10, 2015


REVISION	DATE

SHEET NUMBER:


A2.1

© 2015 SMP ARCHITECTURE

2/10/2015 3:35:10 PM C:\Users\lucy\Documents\Barrington Town Hall Concept\1_Lucy\Combos.ctb

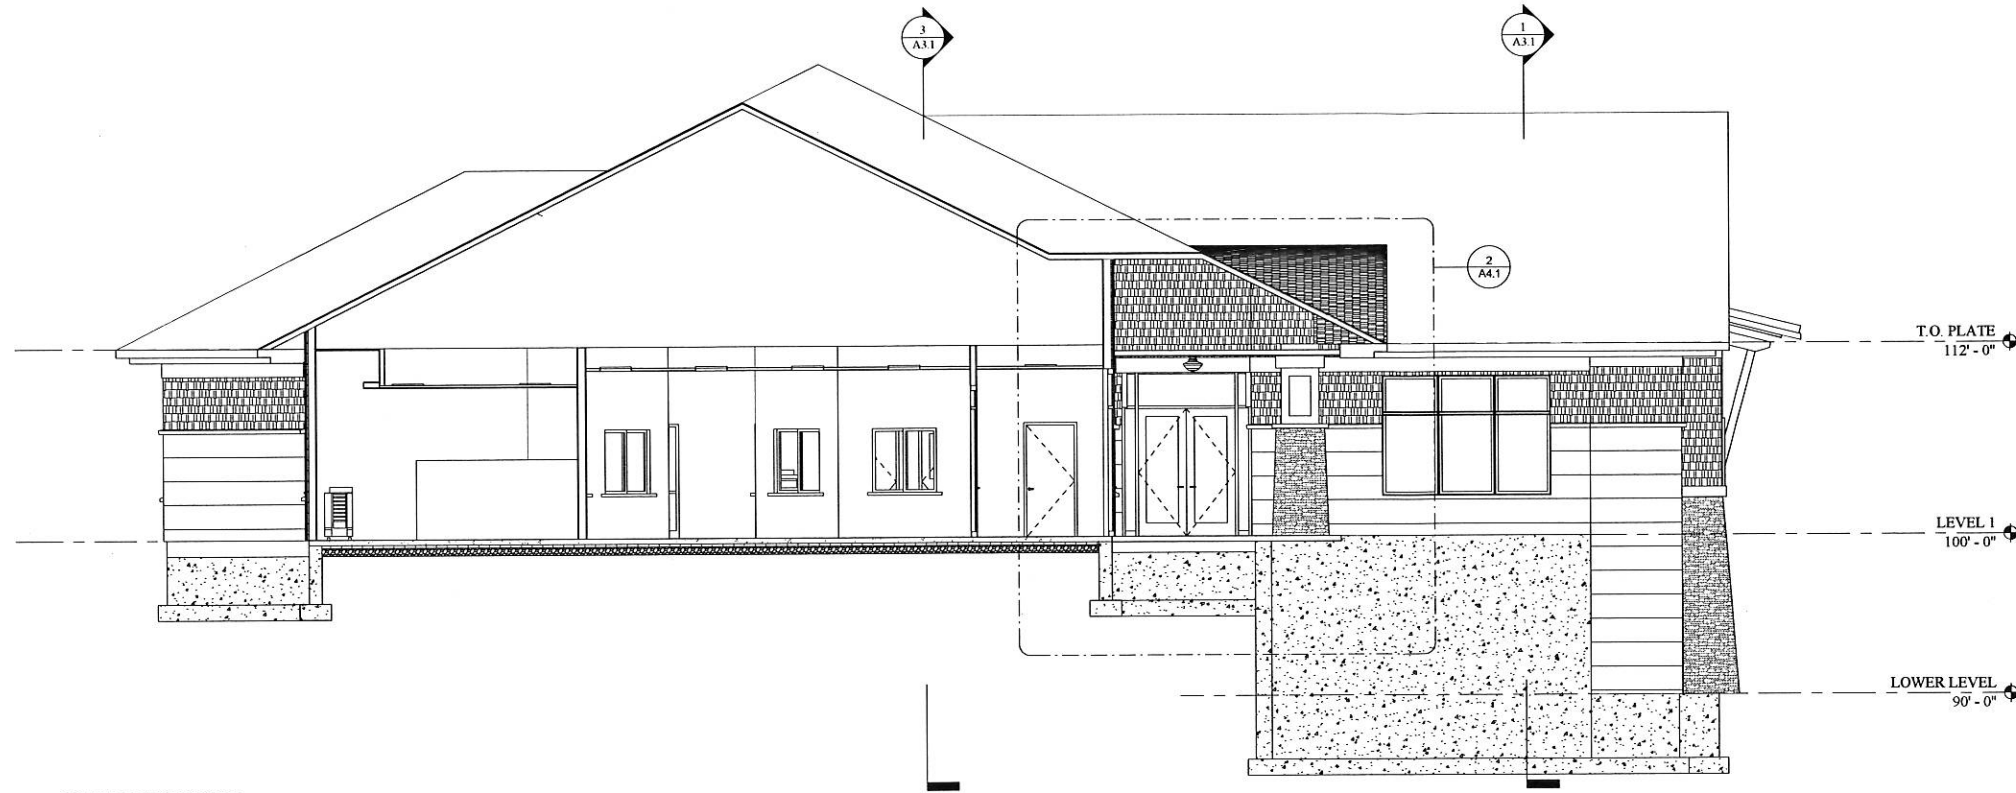

2 BUILDING SECTION E
Scale: 3/16" = 1'-0"

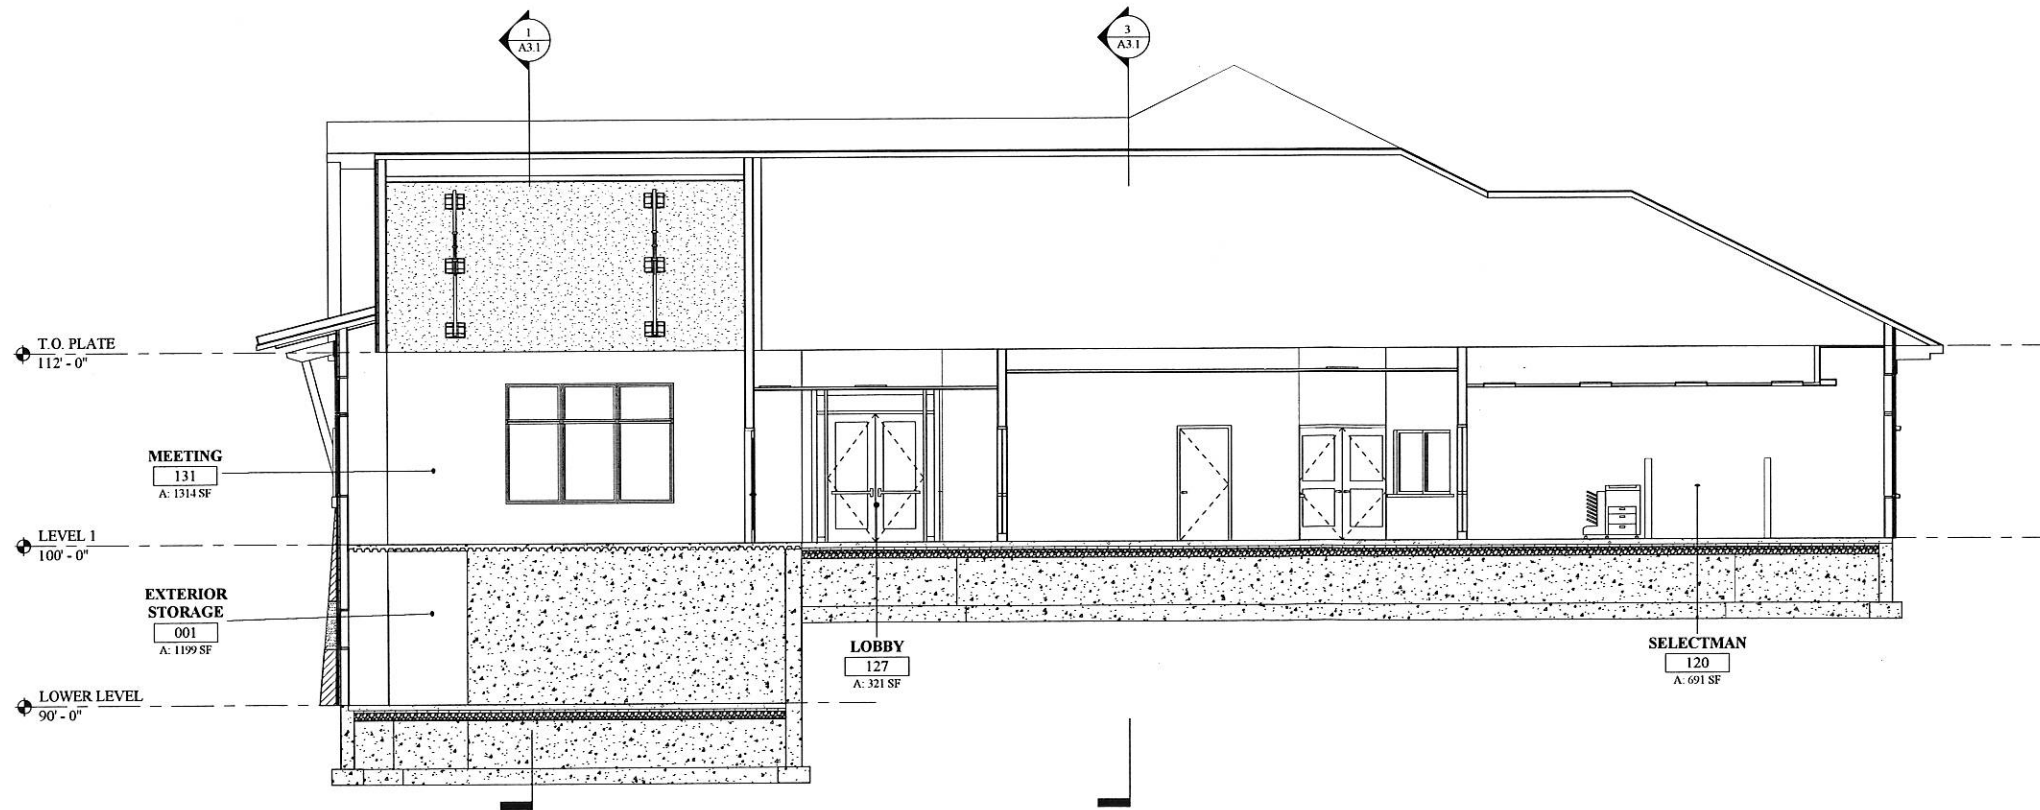

1 BUILDING SECTION D
Scale: 3/16" = 1'-0"

LAND USE OFFICE
FEB 25 2015
RECEIVED
PROGRESS
SET
NOT FOR
CONSTRUCTION

PHONE: 603.228.8880
FAX: 603.228.8881
WWW.SMPARCH.COM



BARRINGTON TOWN OFFICES

Ramsdell Lane, Barrington, New Hampshire 03825

BUILDING SECTIONS

NOTE: IT IS THE OWNER'S AND SUBCONTRACTOR'S RESPONSIBILITY TO REVIEW ALL DRAWINGS & SPECS FOR CONFORMANCE PURPOSES AND TO ENSURE THAT ALL SCOPE OF WORK IS INCLUDED.

PROJECT:

ISSUED: PROGRESS

JOB NO: 1312

DRAWN BY: Author

CHECKED BY: Checker


DATE: February 10, 2015

REVISION	DATE


SHEET NUMBER:

A3.2

2/10/2015 3:35:11 PM C:\Users\jll\OneDrive\Documents\Barrington Town Hall Concept_LJA\CombA.rvt

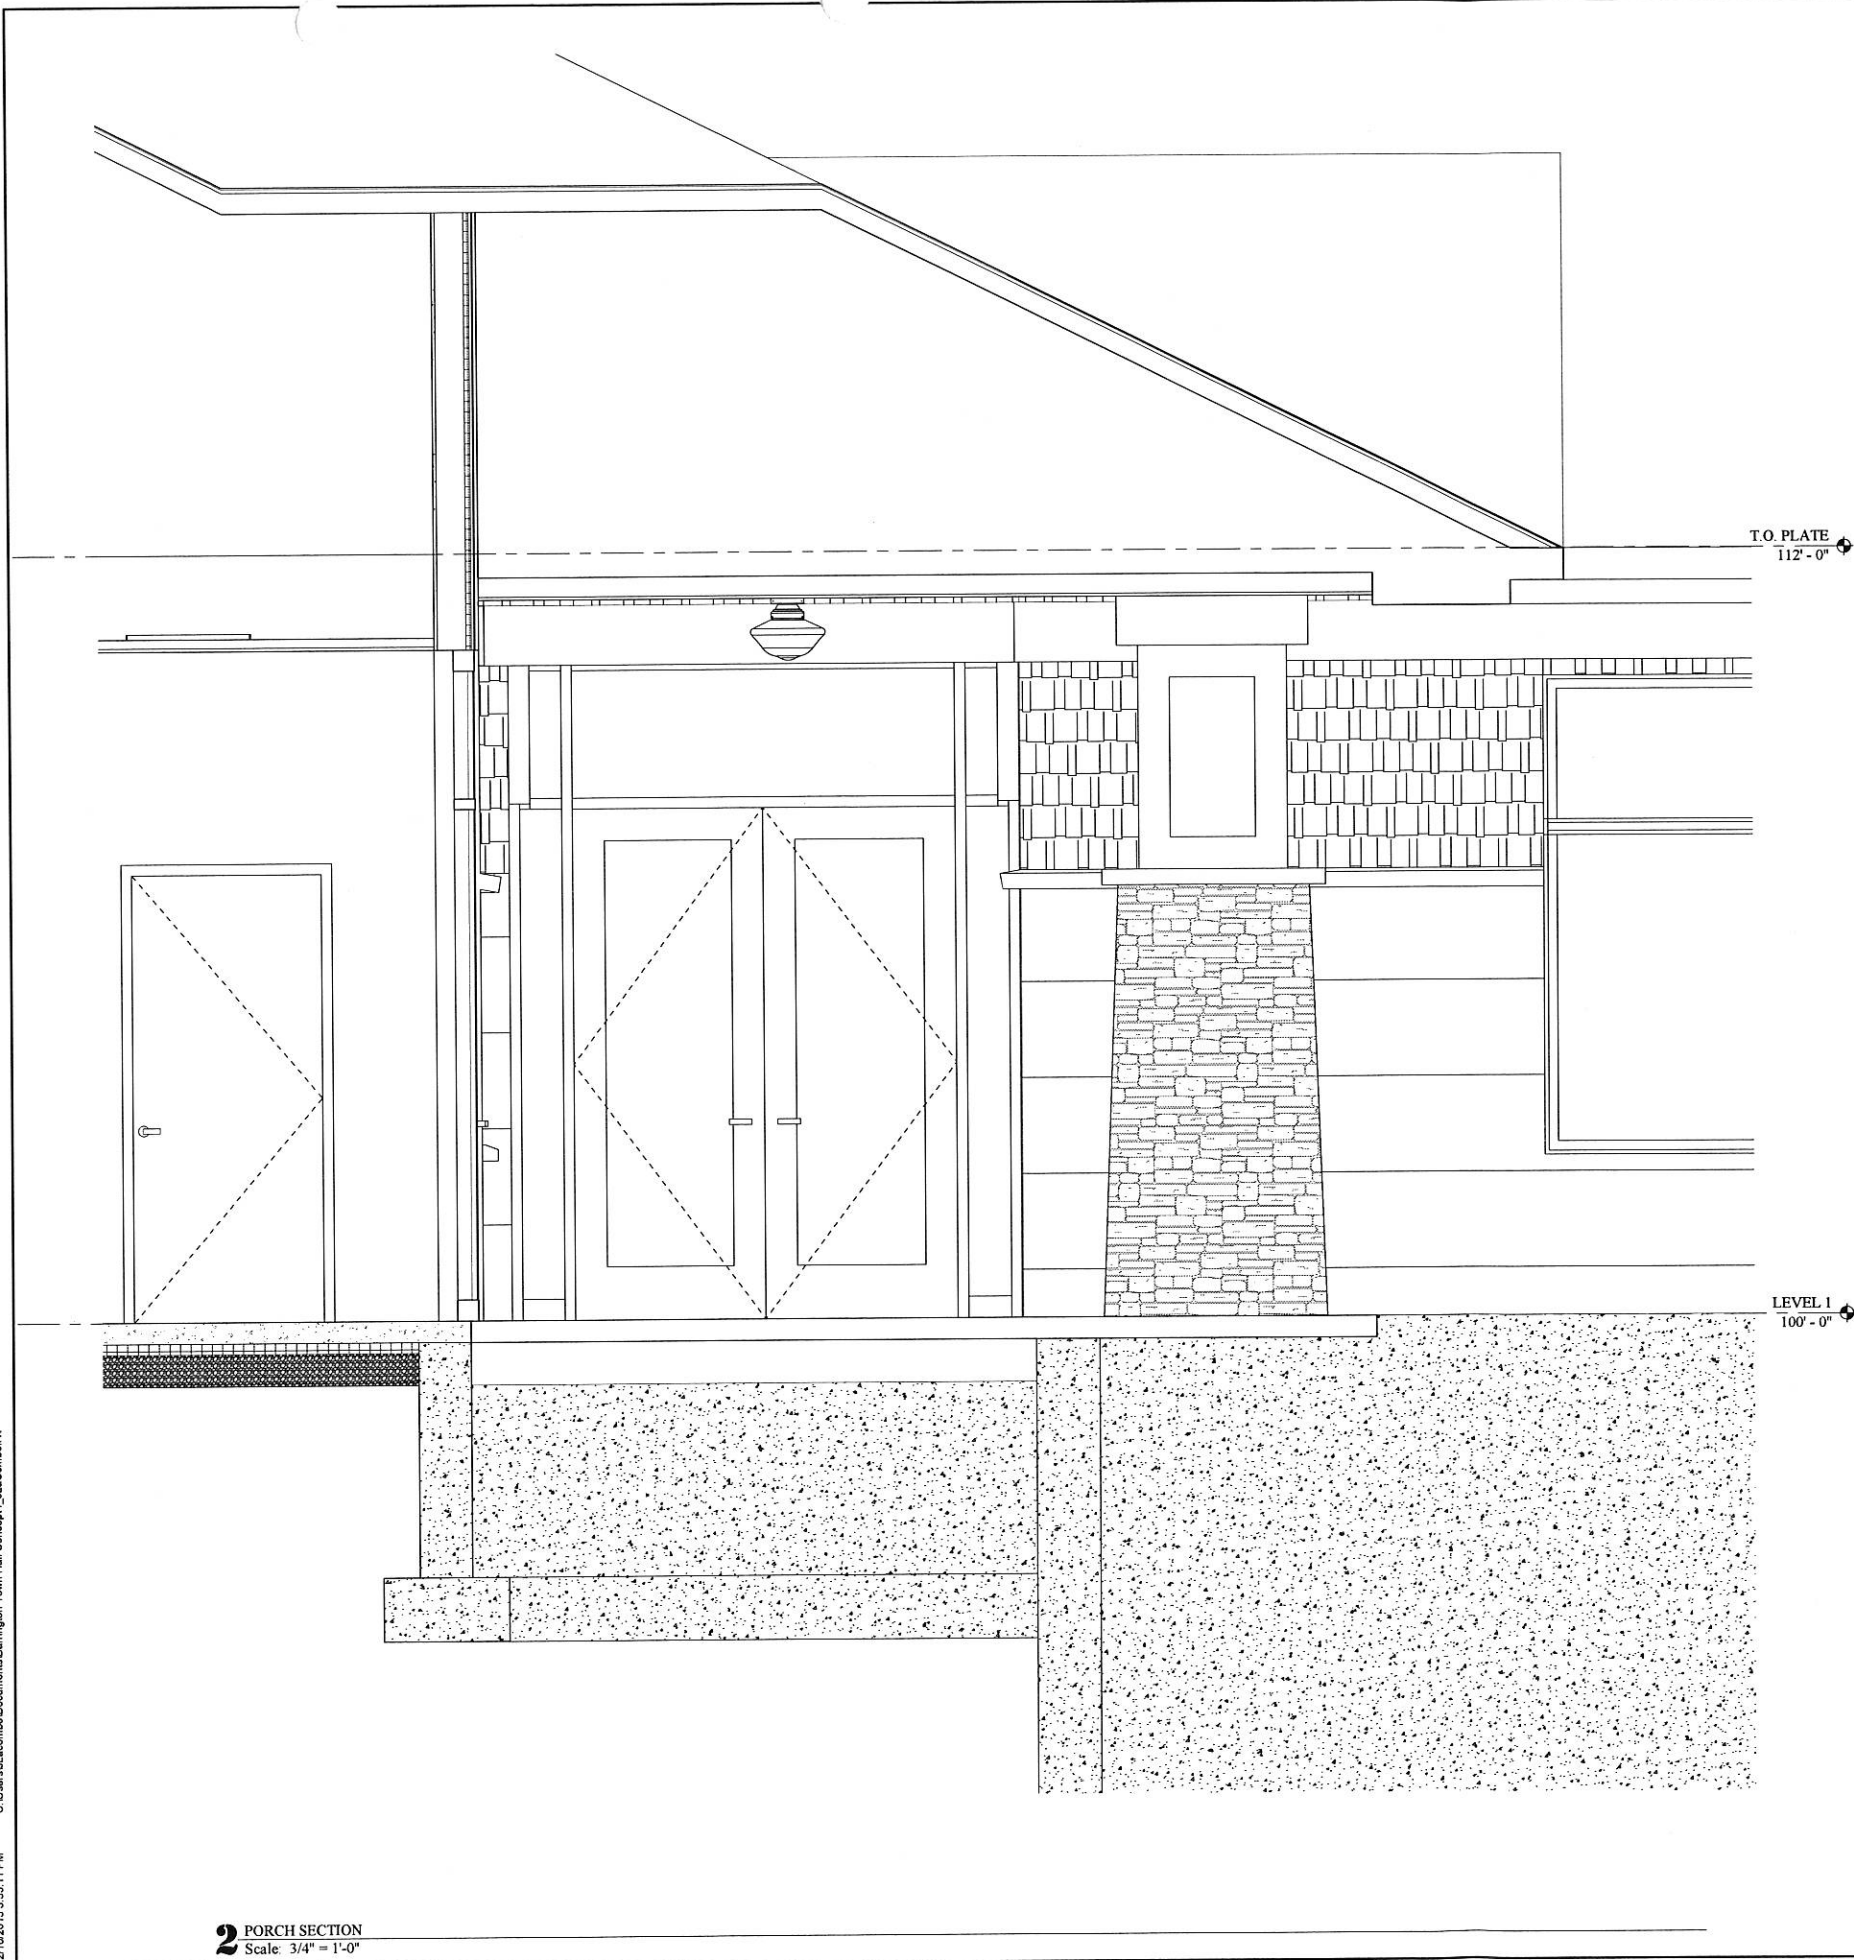

2 PORCH SECTION
Scale: 3/4" = 1'-0"

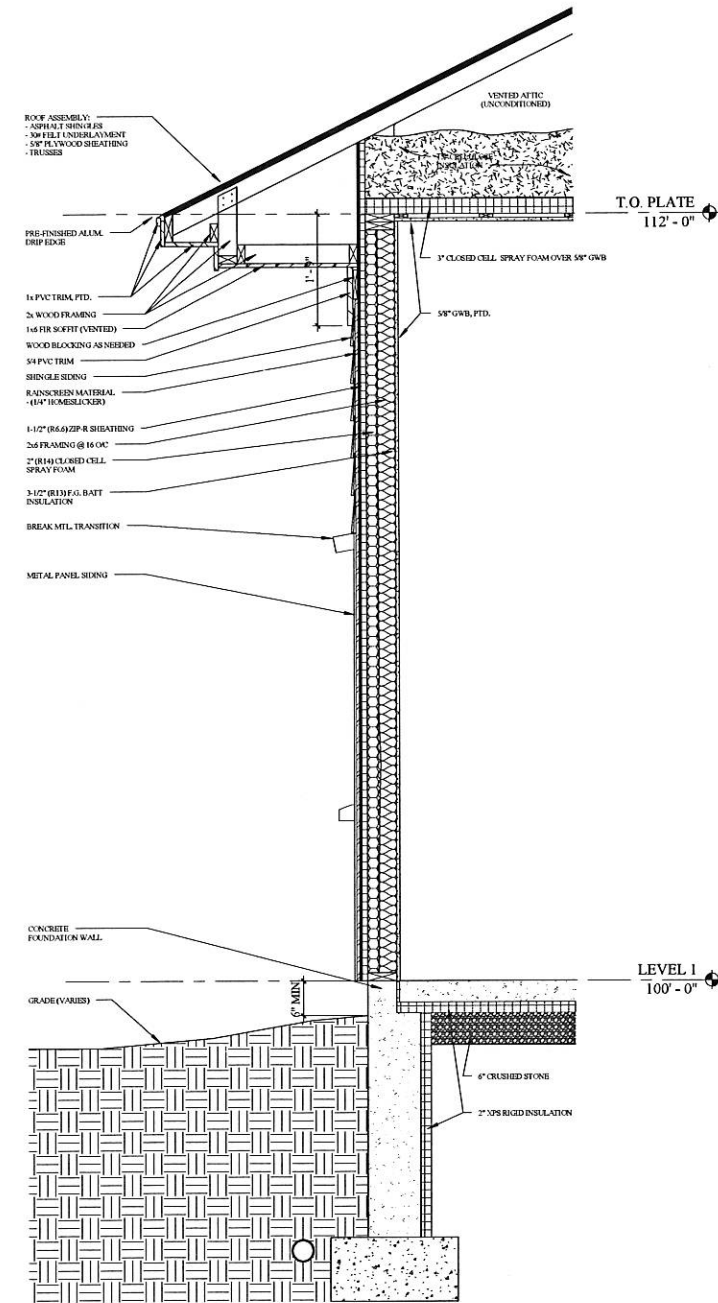

1 CONCEPT WALL SECTION - WOOD STUD ASSEMBLY
Scale: 3/4" = 1'-0"

LAND USE OFFICE
FEB 25 2015
RECEIVED

PHONE: 603.228.8880
FAX: 603.228.8881
WWW.SMPA.COM

smp
ARCHITECTURE

BARRINGTON TOWN OFFICES

Ramsdell Lane, Barrington, New Hampshire 03825

WALL SECTIONS

NOTE: IT IS THE GC'S, CM'S AND SUB-CONTRACTORS RESPONSIBILITY TO REVIEW ALL DRAWINGS & SPECS FOR COORDINATION PURPOSES AND TO ENSURE THAT ALL SCOPE OF WORK IS INCLUDED.

PROJECT:

ISSUED: PROGRESS

JOB NO: 1312

DRAWN BY: Author

CHECKED BY: Checker

DATE: February 10, 2015

REVISION DATE

REVISION DATE


REVISION DATE

REVISION DATE


REVISION DATE

REVISION DATE

REVISION DATE

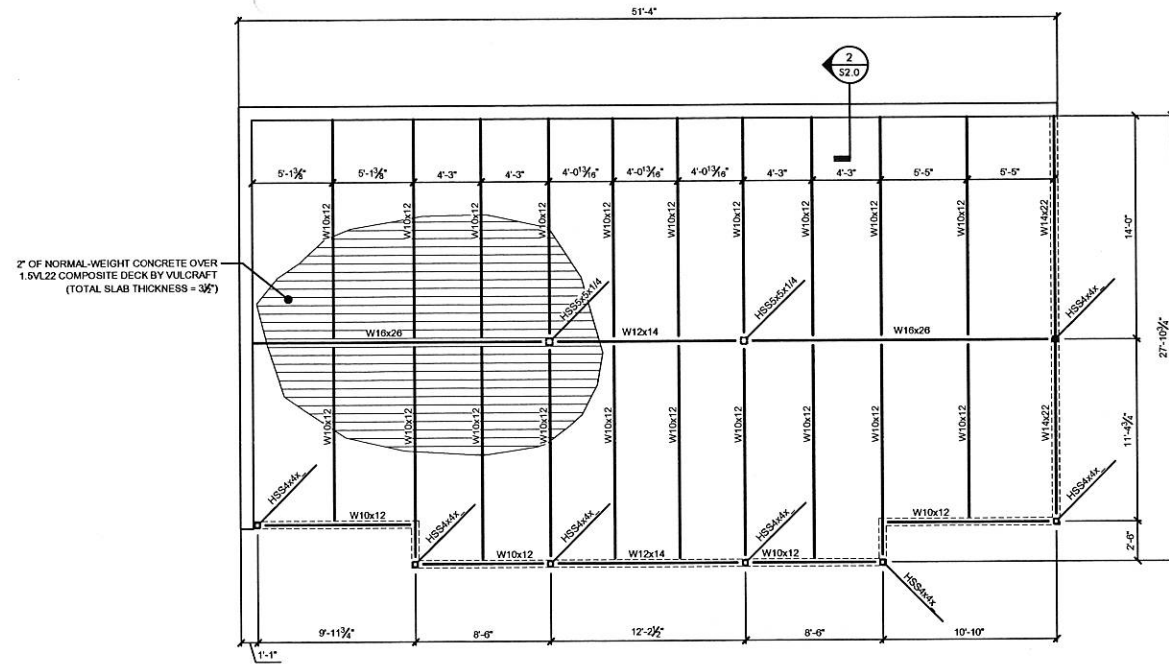

1 FLOOR FRAMING PLAN
S2.0
Scale: 3/16" = 1'-0"

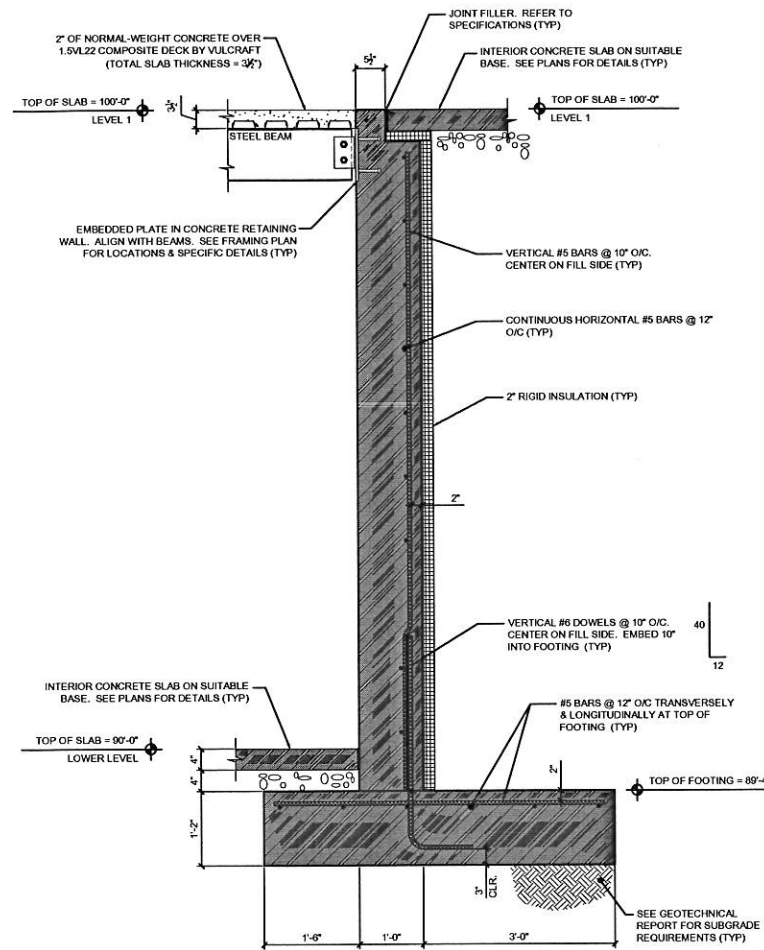

1 LOWER LEVEL RETAINING WALL
S2.0
Scale: 3/4" = 1'-0"

Issued for Client
Review
February 6, 2015

LAND USE OFFICE
FEB 25 2015
RECEIVED

JSN Associates, Inc.
Consulting Structural Engineers
One Autumn Street
Portsmouth, NH 03801
Phone: (603) 433-8639
Fax: (603) 431-2811
www.jsneng.com

PHONE: 603.228.8880
FAX: 603.228.8881
WWW.SMPARCH.COM

BARRINGTON TOWN OFFICES

Ramsdell Lane, Barrington, New Hampshire 03825

FLOOR FRAMING PLAN

PROJECT: BARRINGTON TOWN OFFICES

ISSUED: PROGRESS

JOB NO: 1312

DRAWN BY: HS

CHECKED BY: HS

DATE: February 6, 2015

REVISION	DATE

SHEET NUMBER: **S2.0**

NOTE: IT IS THE GC'S, CM'S AND SUB-CONTRACTORS RESPONSIBILITY TO REVIEW ALL DRAWINGS & SPECS FOR COORDINATION PURPOSES AND TO ENSURE THAT ALL SCOPE OF WORK IS INCLUDED.

	CIRCUIT BREAKER
	GROUND CONNECTION
	HOME RUN TO PANEL (CKT. NO. AS SHOWN)
	TRANSFORMER
	CURRENT TRANSFORMER
	POTENTIAL TRANSFORMER
	20 AMPERE, 120 VOLT DUPLEX RECEPTACLE, +18" AFF
	20 AMPERE, 120 VOLT DOUBLE DUPLEX RECEPTACLE, +18" AFF
	20 AMPERE, 120 VOLT SINGLE RECEPTACLE
	20 AMPERE, 120 VOLT DUPLEX GFCI RECEPTACLE, +18" AFF
	OTHER POWER RECEPTACLE NEMA DESIGNATION AS NOTED
	MOTOR
	JUNCTION BOX
	POWER POLE CONNECTION TO MODULAR FURNITURE WHIP
	TRANSFORMER
	CIRCUIT BREAKER SIZED AS NOTED
	PANELBOARD NORMAL POWER
	PANELBOARD EMERGENCY POWER
	BUS DUCT AMPERE RATING AS NOTED
	FLOOR RECEPTACLE CONDUIT INSTALLED IN SLAB
	UNFUSED SAFETY SWITCH, RATING AS NOTED POLES AMPERES
	FUSED SAFETY SWITCH, RATING AS NOTED FRAMESIZE FUSE/TRIP NEMA RATING
	MAGNETIC MOTOR STARTER, RATING AS NOTED
	MANUAL TOGGLE OPERATED MOTOR STARTER
	ELECTRIC ACTUATED VALVE
	MOTOR CONTACTOR
	CONTACT NORMALLY OPEN
	CONTACT NORMALLY CLOSED
	SELECTOR SWITCH
	TEMPERATURE SWITCH
	PILOT LIGHT

	X	LIGHT FIXTURE
	X	LIGHT FIXTURE W/ EMERGENCY BATTERY BALLAST
	X	WALL MOUNTED LIGHT FIXTURE
	X	PENDANT MOUNTED LIGHT FIXTURE
	X	STRIP/WRAP LIGHT FIXTURE
	X	EXTERIOR WALL-PACK
	X	ROUND RECESSED CEILING MOUNTED FIXTURE
	X	SURFACE MOUNTED FIXTURE
	X	WALL MOUNTED LIGHTING FIXTURE
	X	WALL SCONCE
	X	TRACK LIGHTING FIXTURE (TRACK MOUNTED FIXTURE TYPE MAY VARY)
		EMERGENCY LED EXIT SIGN
		COMBINATION EMERGENCY EXIT SIGN & LIGHTING FIXTURE WITH DUAL LAMPS HEADS BATTERY AND CHARGER
		EMERGENCY LIGHTING FIXTURE WITH DUAL LAMPS HEADS BATTERY AND CHARGER
		REMOTE EMERGENCY LIGHTING LAMP HEAD
		LIGHT SWITCH DENOTES FIXTURE SWITCHED P = PILOT LIGHT (WHERE NOTED) 3 = 3-WAY (WHERE NOTED) 4 = 4-WAY (WHERE NOTED)
	X	ULTRASONIC/INFRARED OCCUPANCY SENSOR C = CEILING MOUNTED W = WALL MOUNTED 48" AFF (TO TOP)
		TIME CLOCK
		LIGHTING CONTACTOR
		PHOTOCELL

[P]	PULL STATION
[V₁]	FIRE ALARM AUDIBLE/VISIBLE NOTIFICATION APPLIANCE (GENERAL EVACUATION)
[H]	
[V₂]	STROBE UNIT XX= CANDELA
[V₁]	NON-SYSTEM STROBE UNIT
[H]	MINI HORN UNIT
[S]	SMOKE DETECTOR
[H]	FIXED TEMP HEAT DETECTOR (135F OR 200F)
[FAP]	FIRE ALARM CONTROL PANEL
[ANN]	ANNUNCIATOR
[MB]	MASTER BOX
[DD]	DIGITAL COMMUNICATOR
[S₂]	DUCT SMOKE DETECTOR
[T]	REMOTE TEST STATION
[TS]	SPRINKLER TAMPER SWITCH
[FS]	SPRINKLER FLOW SWITCH
[PS]	SPRINKLER PRESSURE SWITCH
[MM]	MONITOR MODULE
[CM]	CONTROL MODULE
[S₁]	NON-SYSTEM SMOKE DETECTOR STR = DENOTES INTEGRAL STROBE FOR H/C UNITS
[L₂]	RED MASTER BOX LIGHT
[KB]	KNOX BOX, FBO
[EXT]	HOOD EXT SYSTEM
[DH]	DOOR HOLDER
[FCPS]	SIGNAL POWER EXTENDER

	TELEPHONE SYSTEM WALL JACK
	COMBINATION VOICE/DATA SYSTEM OUTLET
	COMBINATION VOICE/DATA SYSTEM OUTLET IN FLOOR BOX. FURNISH 1" CONDUIT IN SLAB
	CATV JACK
	SECURITY SYSTEM DOOR SWITCH
	ELECTRIC DOOR LOCK SET
	SECURITY SYSTEM CARD ACCESS PAD
	INTERCOM SYSTEM SPEAKER
	INTERCOM MASTER STATION
	CABLE TRAY
	PUSH BUTTON
	DOOR BELL

1. ALL WORK SHALL BE IN COMPLIANCE WITH NFPA-70, NATIONAL ELECTRICAL CODE.
2. ALL MOTOR SAFETY SWITCHES, DISCONNECTS AND MOTOR STARTERS ARE FURNISHED BY DIVISION 16000 UNLESS NOTED AS FURNISHED WITH EQUIPMENT (FWE).
3. UNLESS OTHERWISE NOTED, CONVENIENCE RECEPTACLES SHALL BE MOUNTED 18 INCHES AFF AND LIGHTING TOGGLE SWITCHES 48 INCHES AFF.
4. ALL PENETRATIONS THROUGH FLOORS, RATED WALLS AND PARTITIONS SHALL BE SEALED WITH A UL APPROVED FIRE SEALANT MATERIAL TO MAINTAIN THE RATING OF THE SEPARATION.
5. LIGHTING TOGGLE SWITCHES SHALL BE COMMERCIAL SPECIFICATION GRADE, 120 VOLT, SIDE WIRED AS MANUFACTURED BY LEVITON, PASS & SEYMOUR, OR APPROVED EQUAL.
6. CONVENIENCE RECEPTACLES SHALL BE COMMERCIAL SPECIFICATION GRADE UNLESS SHOWN OTHERWISE, GROUNDING TYPE, NEMA 5-20R, SIDE WIRED, AS MANUFACTURED BY LEVITON, PASS & SEYMOUR, OR APPROVED EQUAL.
7. DEVICE COVERPLATES SHALL BE THERMOPLASTIC NYLON TYPE WITH IVORY FINISH IN ALL FINISHED SPACES. MECHANICAL ROOMS, ELECTRICAL ROOM, AND UTILITY ROOMS SHALL BE FURNISHED WITH BRUSHED STAINLESS STEEL COVERPLATES.
8. UNLESS OTHERWISE NOTED ALL HOMERUNS FOR 15 OR 20A CIRCUITS SHALL BE 2#12AWG & #12 GND. HOMERUNS FED FROM 20A, 1P CIRCUITS IN EXCESS OF 100 FEET (FOR 120V CIRCUITS) SHALL BE #10AWG. ALL WIRING SHALL BE COPPER.
9. CONDUIT SYSTEMS: EXPOSED INTERIOR CONDUITS SHALL BE EMT, 3/4" MINIMUM. PROPERLY SUPPORTED MC CABLE ASSEMBLIES MAY BE USED ABOVE CEILINGS AND IN WALLS. FLEXIBLE LIQUIDTIGHT CONDUIT WHIPS SHALL BE USED FOR CONNECTION TO VIBRATING EQUIPMENT IN THE MECHANICAL ROOM.

AC	AMPERE	MCB	LOW VOLTAGE
AC	ALTERNATING CURRENT	MCC	MAIN CIRCUIT BREAKER
AF	ABOVE FINISHED FLOOR	MCP	MOTOR CONTROL CENTER
AFG	ABOVE FINISHED GRADE	MH	MOTOR CIRCUIT PROTECTION
AIC	AMPERES INTERRUPTING CAPACITY	EMH	METAL HALIDE
AL	ALUMINUM	MLO	ELECTRICAL MANHOLE
ASYM	ASYMMETRICAL	NO	MAIN LUGS ONLY
ATS	AUTOMATIC TRANSFER SWITCH	MOD	MECHANICALLY OPERATED
AUX	AUXILIARY	MTS	MOTOR OPERATED DAMPER
AWG	AMERICAN WIRE GAUGE	MV	MANUAL TRANSFER SWITCH
BKR	BREAKER	NC	MERCURY VAPOR
C	CONDUIT	NO	MEGAVOLT-AMPERE
CAB	CABINET	NO	NORMALLY CLOSED
CB	CIRCUIT BREAKER	OH	NORMALLY OPENED
CKT	CIRCUIT	OL	OVERHEAD
CT	CURRENT TRANSFORMER	OOA	OVER LOAD
CU	COPPER	OSY	ON-OFF-AUTOMATIC
DC	DIRECT CURRENT	P	OUTSIDE STEM & YOKE VALVE (FA SYSTEM)
DISC	DISCONNECT	PB	POLE
EG	EQUIPMENT GROUND	PF	PUSH BUTTON
EH	ELECTRICALLY HELD	PH	POWER FACTOR
EM	EMERGENCY	PNL	PHASE
EMT	ELECTRICAL METALLIC TUBING	PRI	PANEL
EO	ELECTRICALLY OPERATED	PT	PRIMARY
EPR	ETHYLENE PROPYLENE RUBBER	PVC	POTENTIAL TRANSFORMER
EQUIP	EQUIPMENT	RGSC	POLYVINYL CHLORIDE
EX	EXTERIOR	RVSS	RIGID GALVANIZED STEEL CONDUIT
FA	FIRE ALARM	RSC	REDUCED VOLTAGE SOLID STATE
FC	FOOT-CANDLE	RVAT	RIGID STEEL CONDUIT
FDR	FEEDER	S	REDUCED VOLTAGE AUTO TRANSFORMER
FLUOR	FLUORESCENT	SEC	SIGNAL
FS	FLOW SWITCH (FA SYSTEM)	SHLD	SECONDARY
FVNR	FULL VOLTAGE NON REVERSING	SW	SHIELDED CABLE
FVR	FULL VOLTAGE REVERSING	SWBD	SWITCH
GEN	GENERATOR	SYM	SWITCHBOARD
GF	GROUND FAULT	T	SYMMETRICAL
GFI	GROUND FAULT CIRCUIT INTERRUPTER	TR	TELEPHONE
GND	GROUND	TBD	TRANSFORMER
H	HAND HOLE	TD	TO BE DETERMINED
HOA	HAND-OFF-AUTOMATIC	TDR	TELEADLER
HP	HORSE POWER	TEL	TIME DELAY RELAY
HPS	HIGH PRESSURE SODIUM	TM	TELEPHONE
HV	HIGH VOLTAGE	UG	TELEMETRY
HZ	HERTZ	UT	UNDERGROUND
IG	ISOLATED GROUND	V	UTILITY
IMC	INTERMEDIATE METAL CONDUIT	V	VOLT
INCAND	INCANDESCENT	VA	VOLT-AMPERE
JB	JUNCTION BOX	VFD	VARIABLE FREQUENCY DRIVE
KCMIL	THOUSAND CIRCULAR MILS	W	WATT
KV	KILOVOLT	WH	WATT HOUR
KVA	KILO VOLT-AMPERE	WP	WEATHERPROOF
KW	KILO WATT	XFMR	TRANSFORMER
KWH	KILOWATT HOUR	XP	CROSS LINKED POLYETHYLENE
LPS	LOW PRESSURE SODIUM		EXPLSION PROOF
LTG	LIGHTING		
LSW	LIGHT SWITCH		

NOTE: IT IS THE GC'S, CMC'S AND SUB-CONTRACTORS RESPONSIBILITY TO REVIEW ALL DRAWINGS & SPECS FOR COORDINATION PURPOSES AND TO ENSURE THAT ALL SCOPE OF WORK IS INCLUDED.

ELECTRICAL LEGEND, SYMBOLS, & NOTES

PHONE: 603.228.8880
FAX: 603.228.8881
WWW.SHEER.COM



NOTE: IT IS THE GC'S, CM's AND SUB-CONTRACTORS RESPONSIBILITY TO REVIEW ALL	PROJECT:		DRAWING TITLE:	
	ISSUED:		PROGRESS	
	JOB NO:	1312		
	DRAWN BY:	JMD		
	CHECKED BY:	TDM		
	DATE:	February 3, 2015		
	REVISION	DATE		
	SHEET NUMBER:			


EO.0

© 2015 SMP ARCHITECTURE

2/4/2015 12:05:18 PM C:\Users\JLacombe\Documents\Barrington Town Hall Concept_L_JLaCombe.rvt

NOTES:

1. SEE E0.0 FOR LEGEND, ABBREVIATIONS AND GENERAL NOTES.

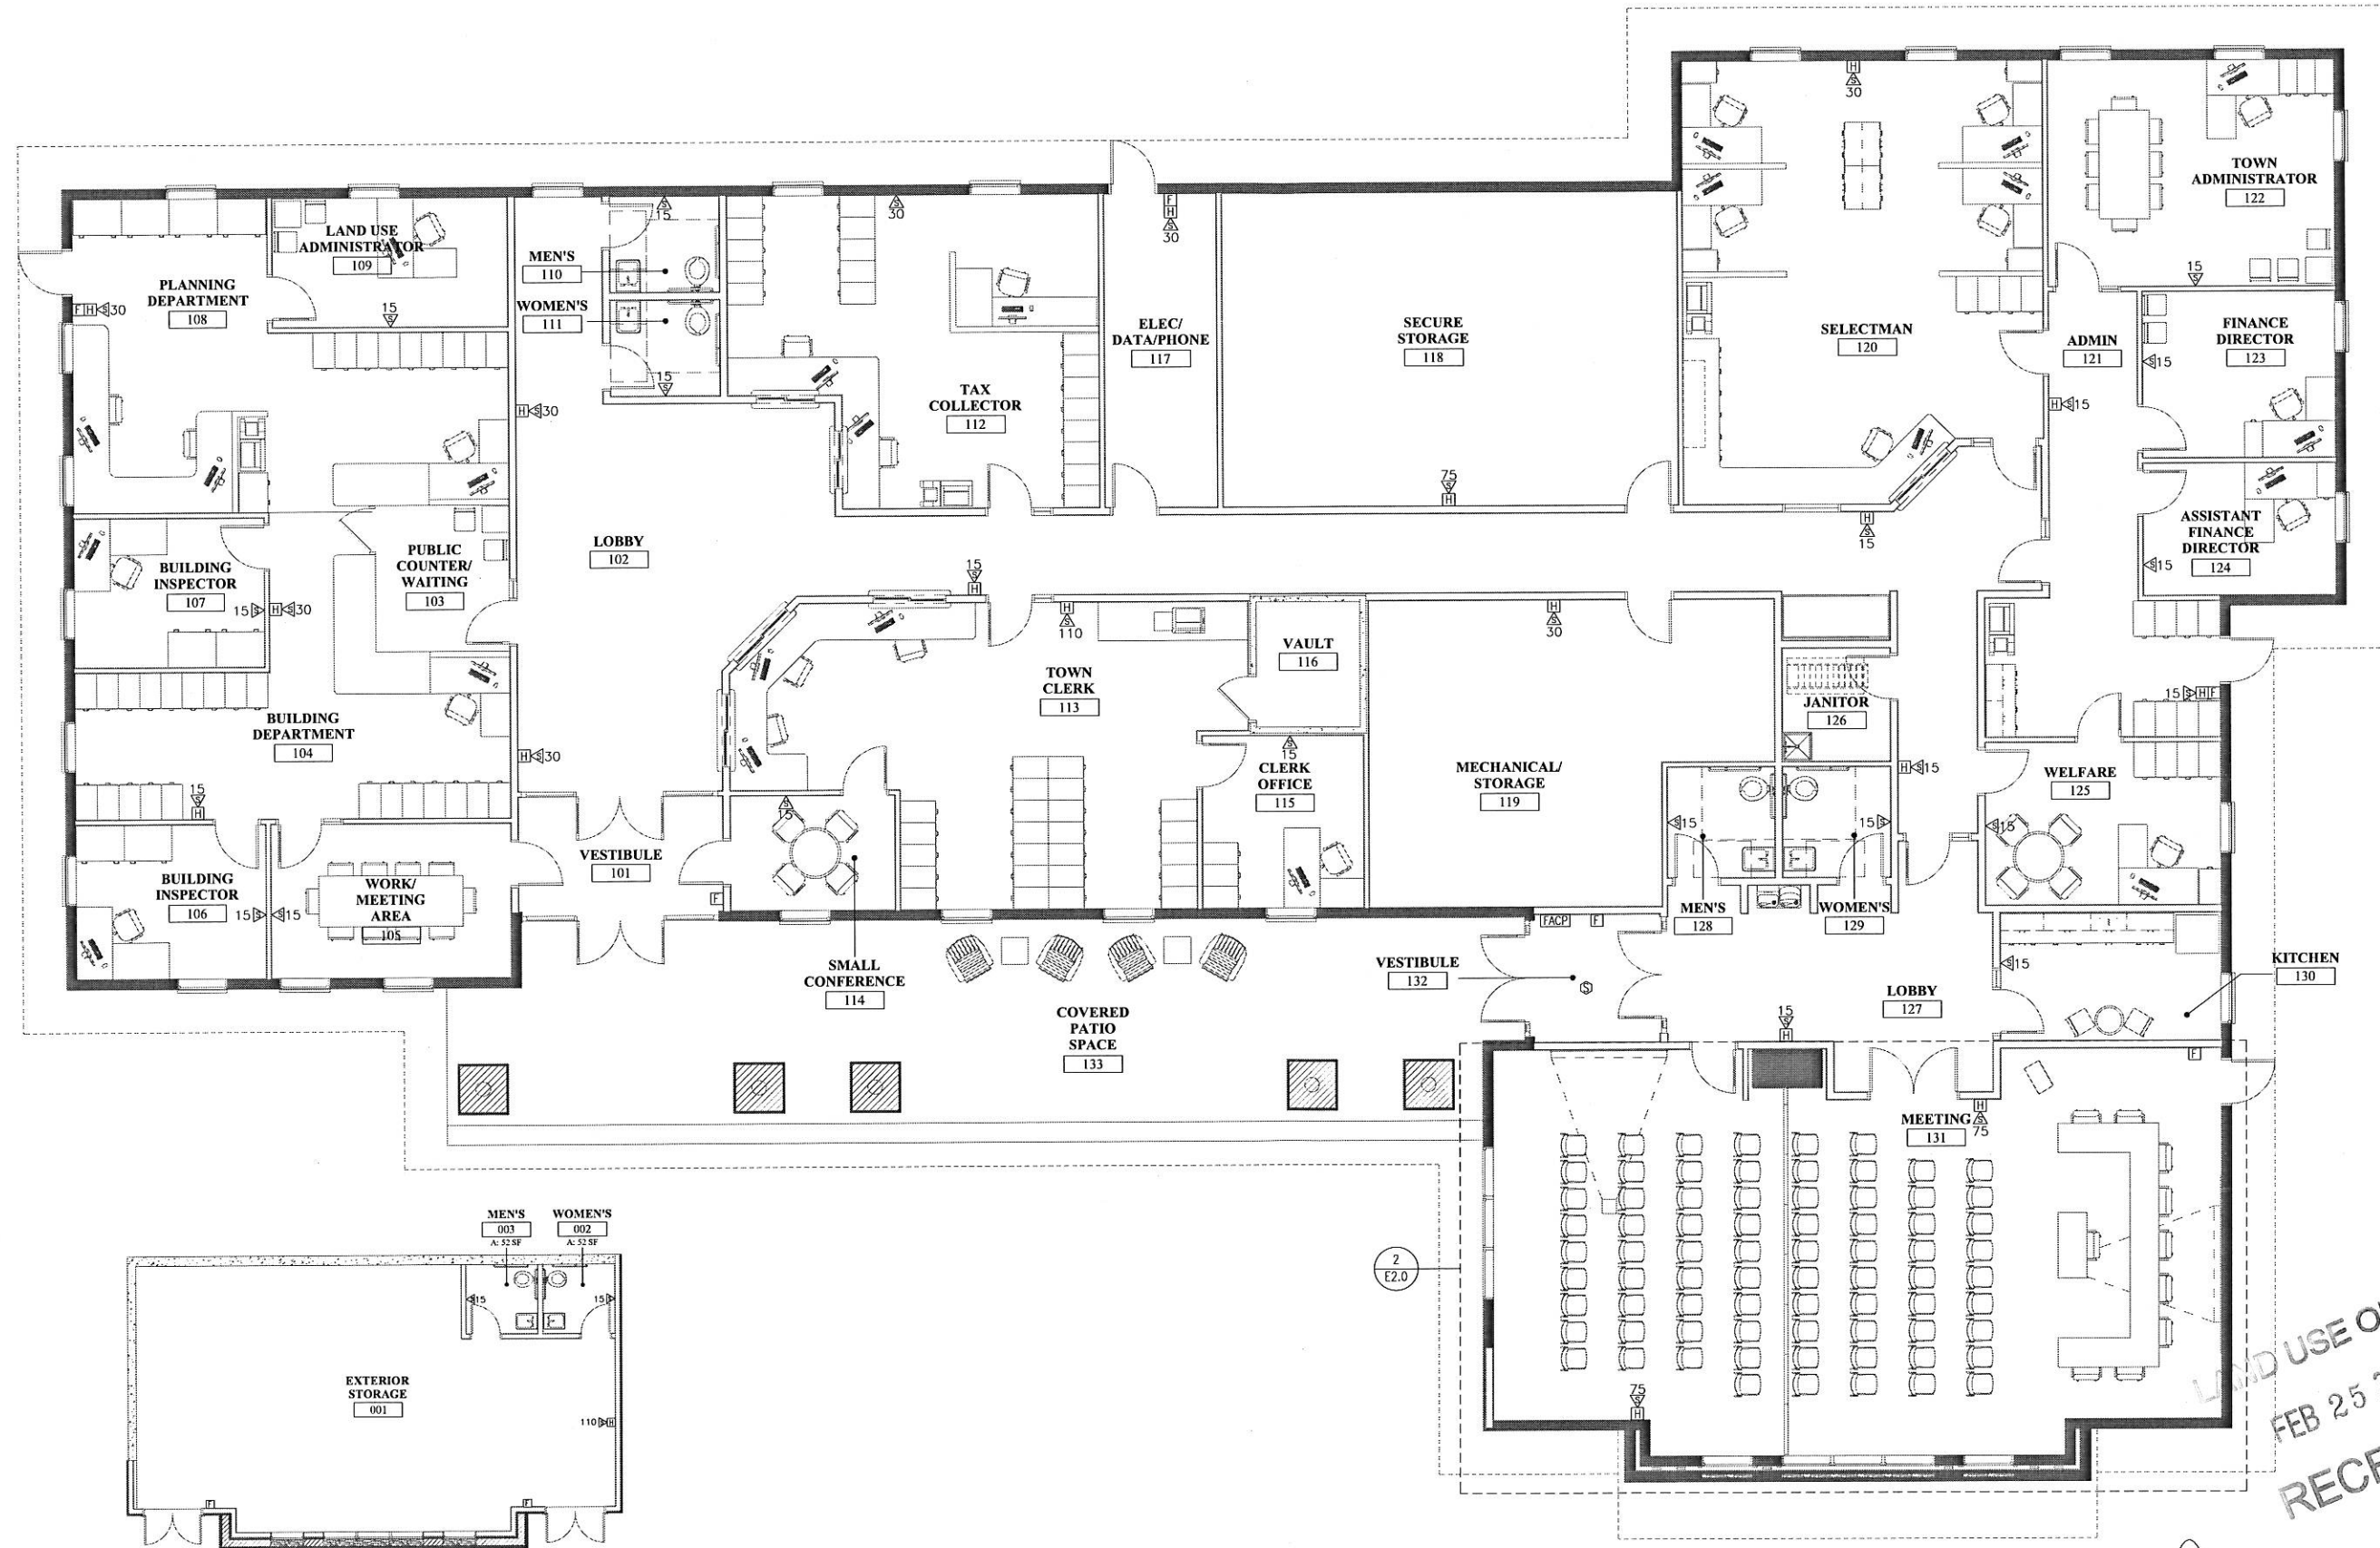

2 ELECTRICAL LIGHTING & FIRE ALARM PLAN - LOWER LEVEL
SCALE: 1/8"=1'

1 ELECTRICAL LIGHTING & FIRE ALARM PLAN - FIRST FLOOR
SCALE: 3/16"=1'

SWIFTCURRENT
Engineering Services
10 Forest Falls Dr. Unit 4b
Yarmouth, ME 04096
Tel: (207) 847-9280

PHONE: 603.228.8880
FAX: 603.228.8881
WWW.SMPARCH.COM



BARRINGTON TOWN OFFICES

Ramstell Lane, Barrington, New Hampshire 03825

DRAWING TITLE: ELECTRICAL LIGHTING & FIRE ALARM PLAN - FIRST FLOOR & LOWER LEVEL

NOTE: IT IS THE USER'S AND SUB-CONTRACTOR'S RESPONSIBILITY TO REVIEW ALL DRAWINGS & SPECS FOR COORDINATION PURPOSES AND TO ENSURE THAT ALL SCOPE OF WORK IS INCLUDED.

ISSUED:	PROGRESS
JOB NO:	1312
DRAWN BY:	JMD
CHECKED BY:	TDM
DATE:	February 3, 2015
REVISION	DATE

SHEET NUMBER:

E2.0